

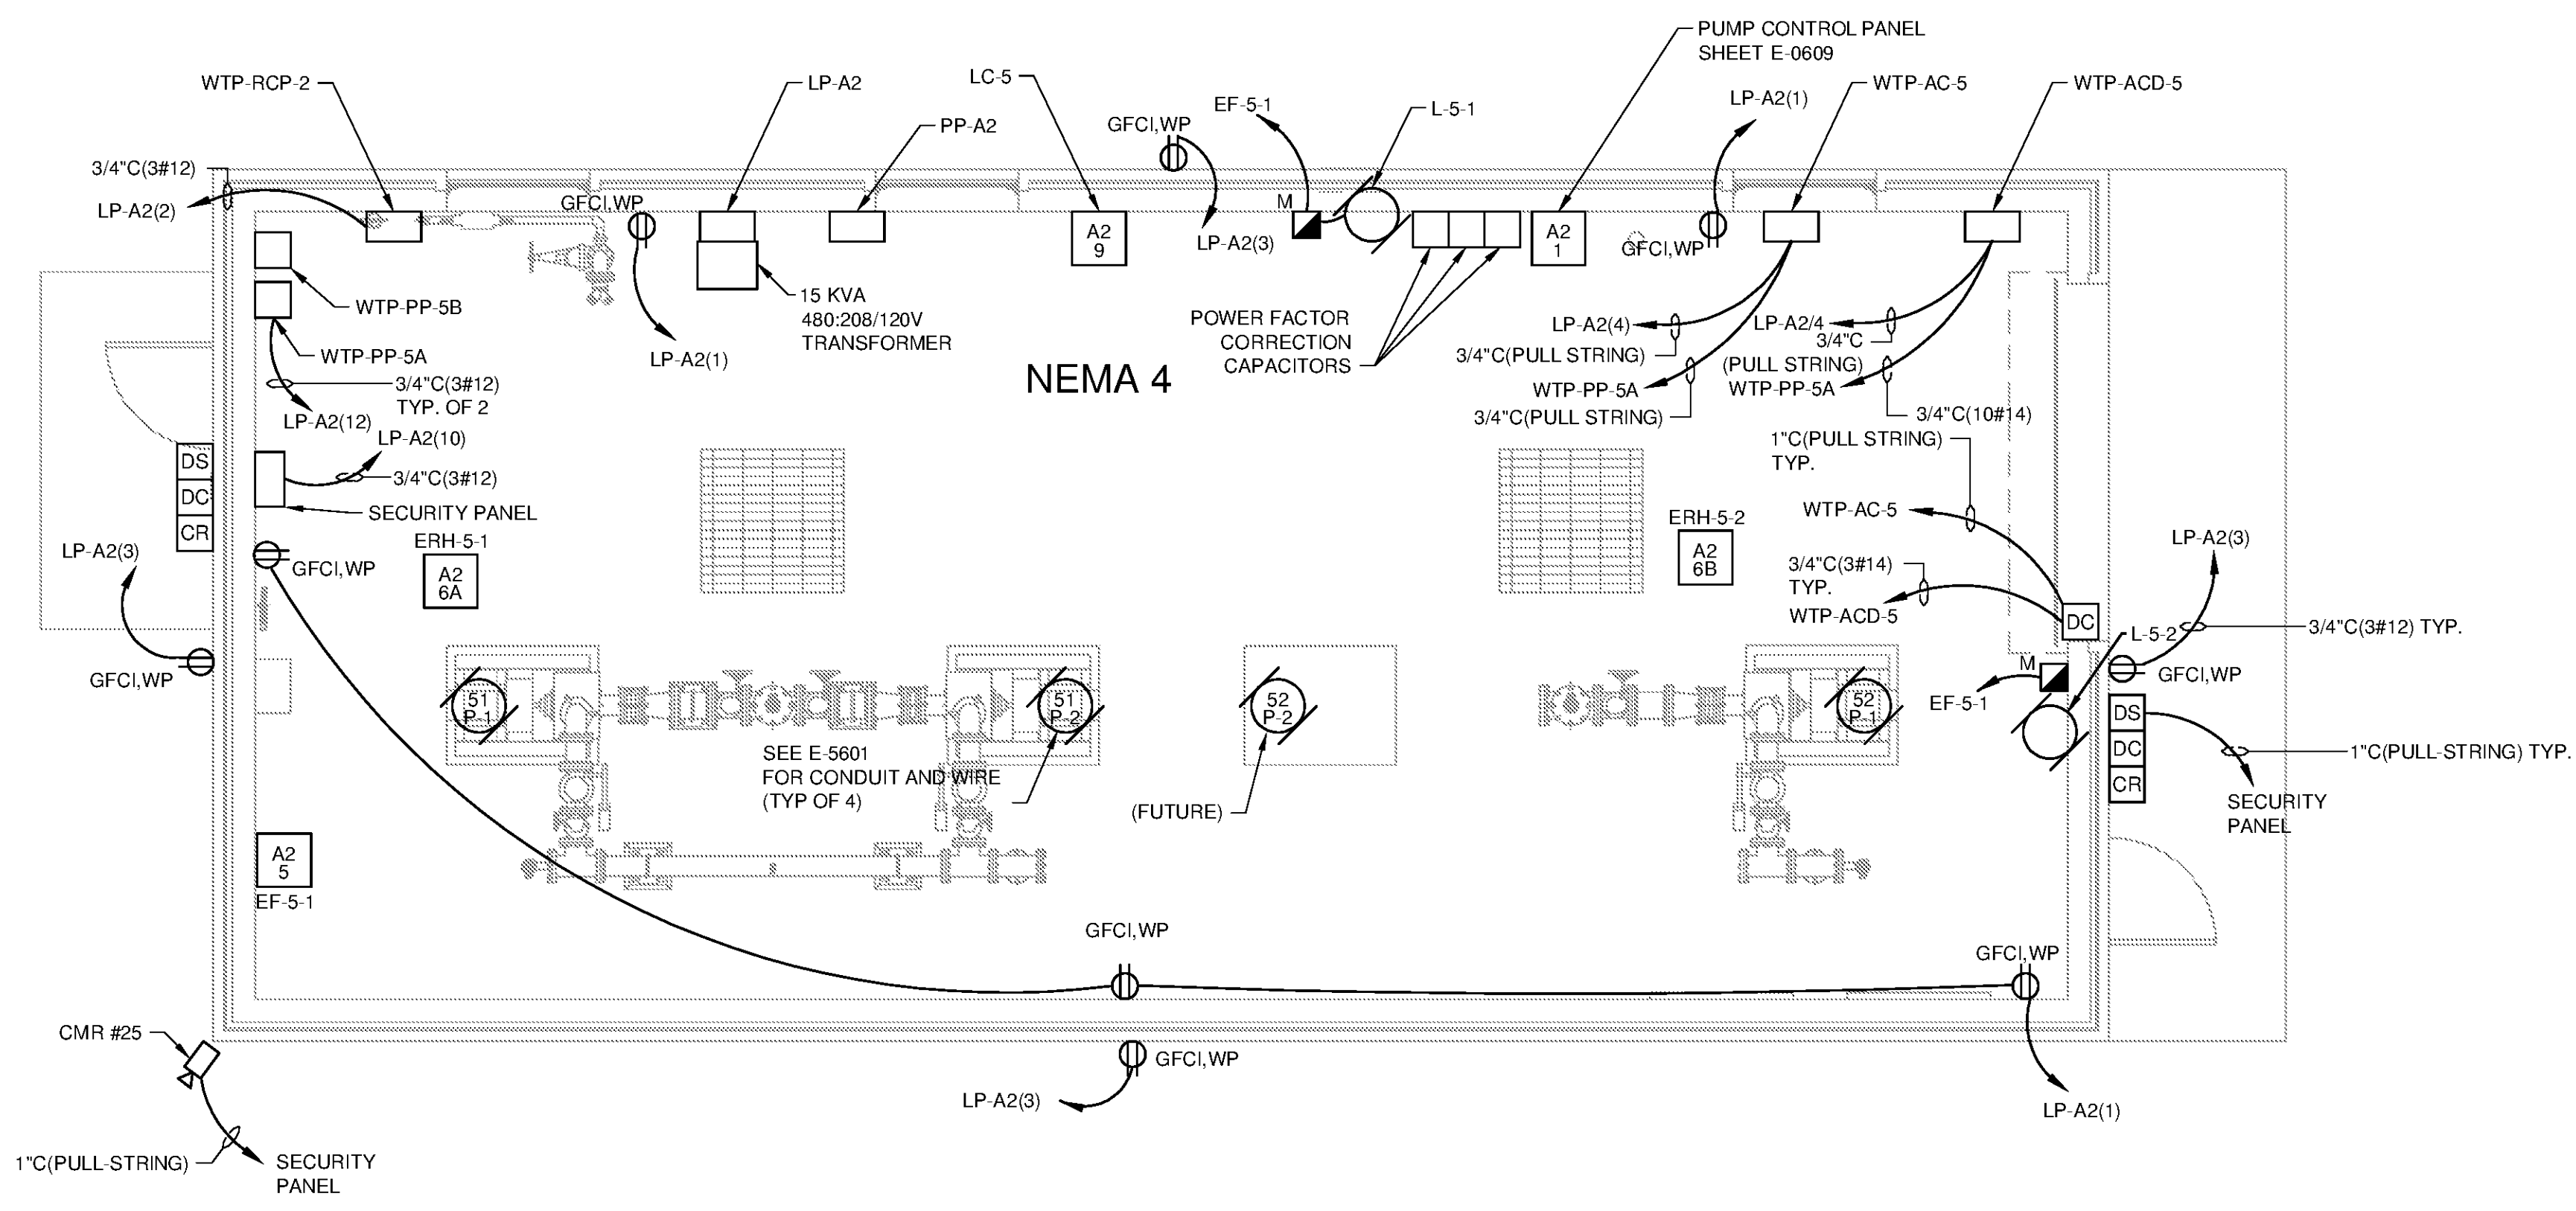


10/17/2014 11:00:47 AM - P:\IER\11740\200-11740-10003\CAD\SHEETFILES\TREATMENT PLANT\WTP E-5401 ELECTRICAL PLAN - THICKENED SLUDGE RECYCLE PUMP STATION.DWG - CALZARETTA, TIMOTHY

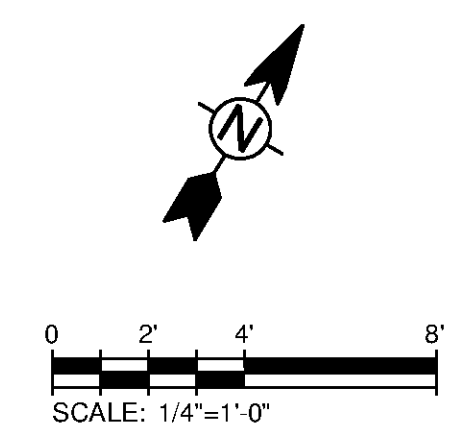

**PLAN**  
SCALE: 1/4"=1'-0"

**TETRA TECH**  
www.tetra-tech.com  
101 QUALITY CIRCLE, SUITE 140  
HUNTSVILLE, ALABAMA 35806  
PHONE: (256) 424-4077 FAX: (256) 424-4097

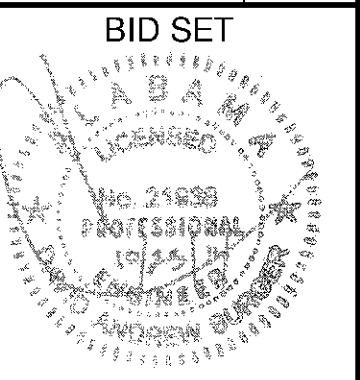

BID SET

MARK	DATE	DESCRIPTION	BY

HUNTSVILLE UTILITIES  
SOUTHEAST WATER TREATMENT PLANT  
**ELECTRICAL PLAN - THICKENED SLUDGE / RECYCLE PUMP STATION**

Project No.:	200-11740-10003
Designed By:	CSW
Drawn By:	CSW
Checked By:	DAB

**E-5401**