
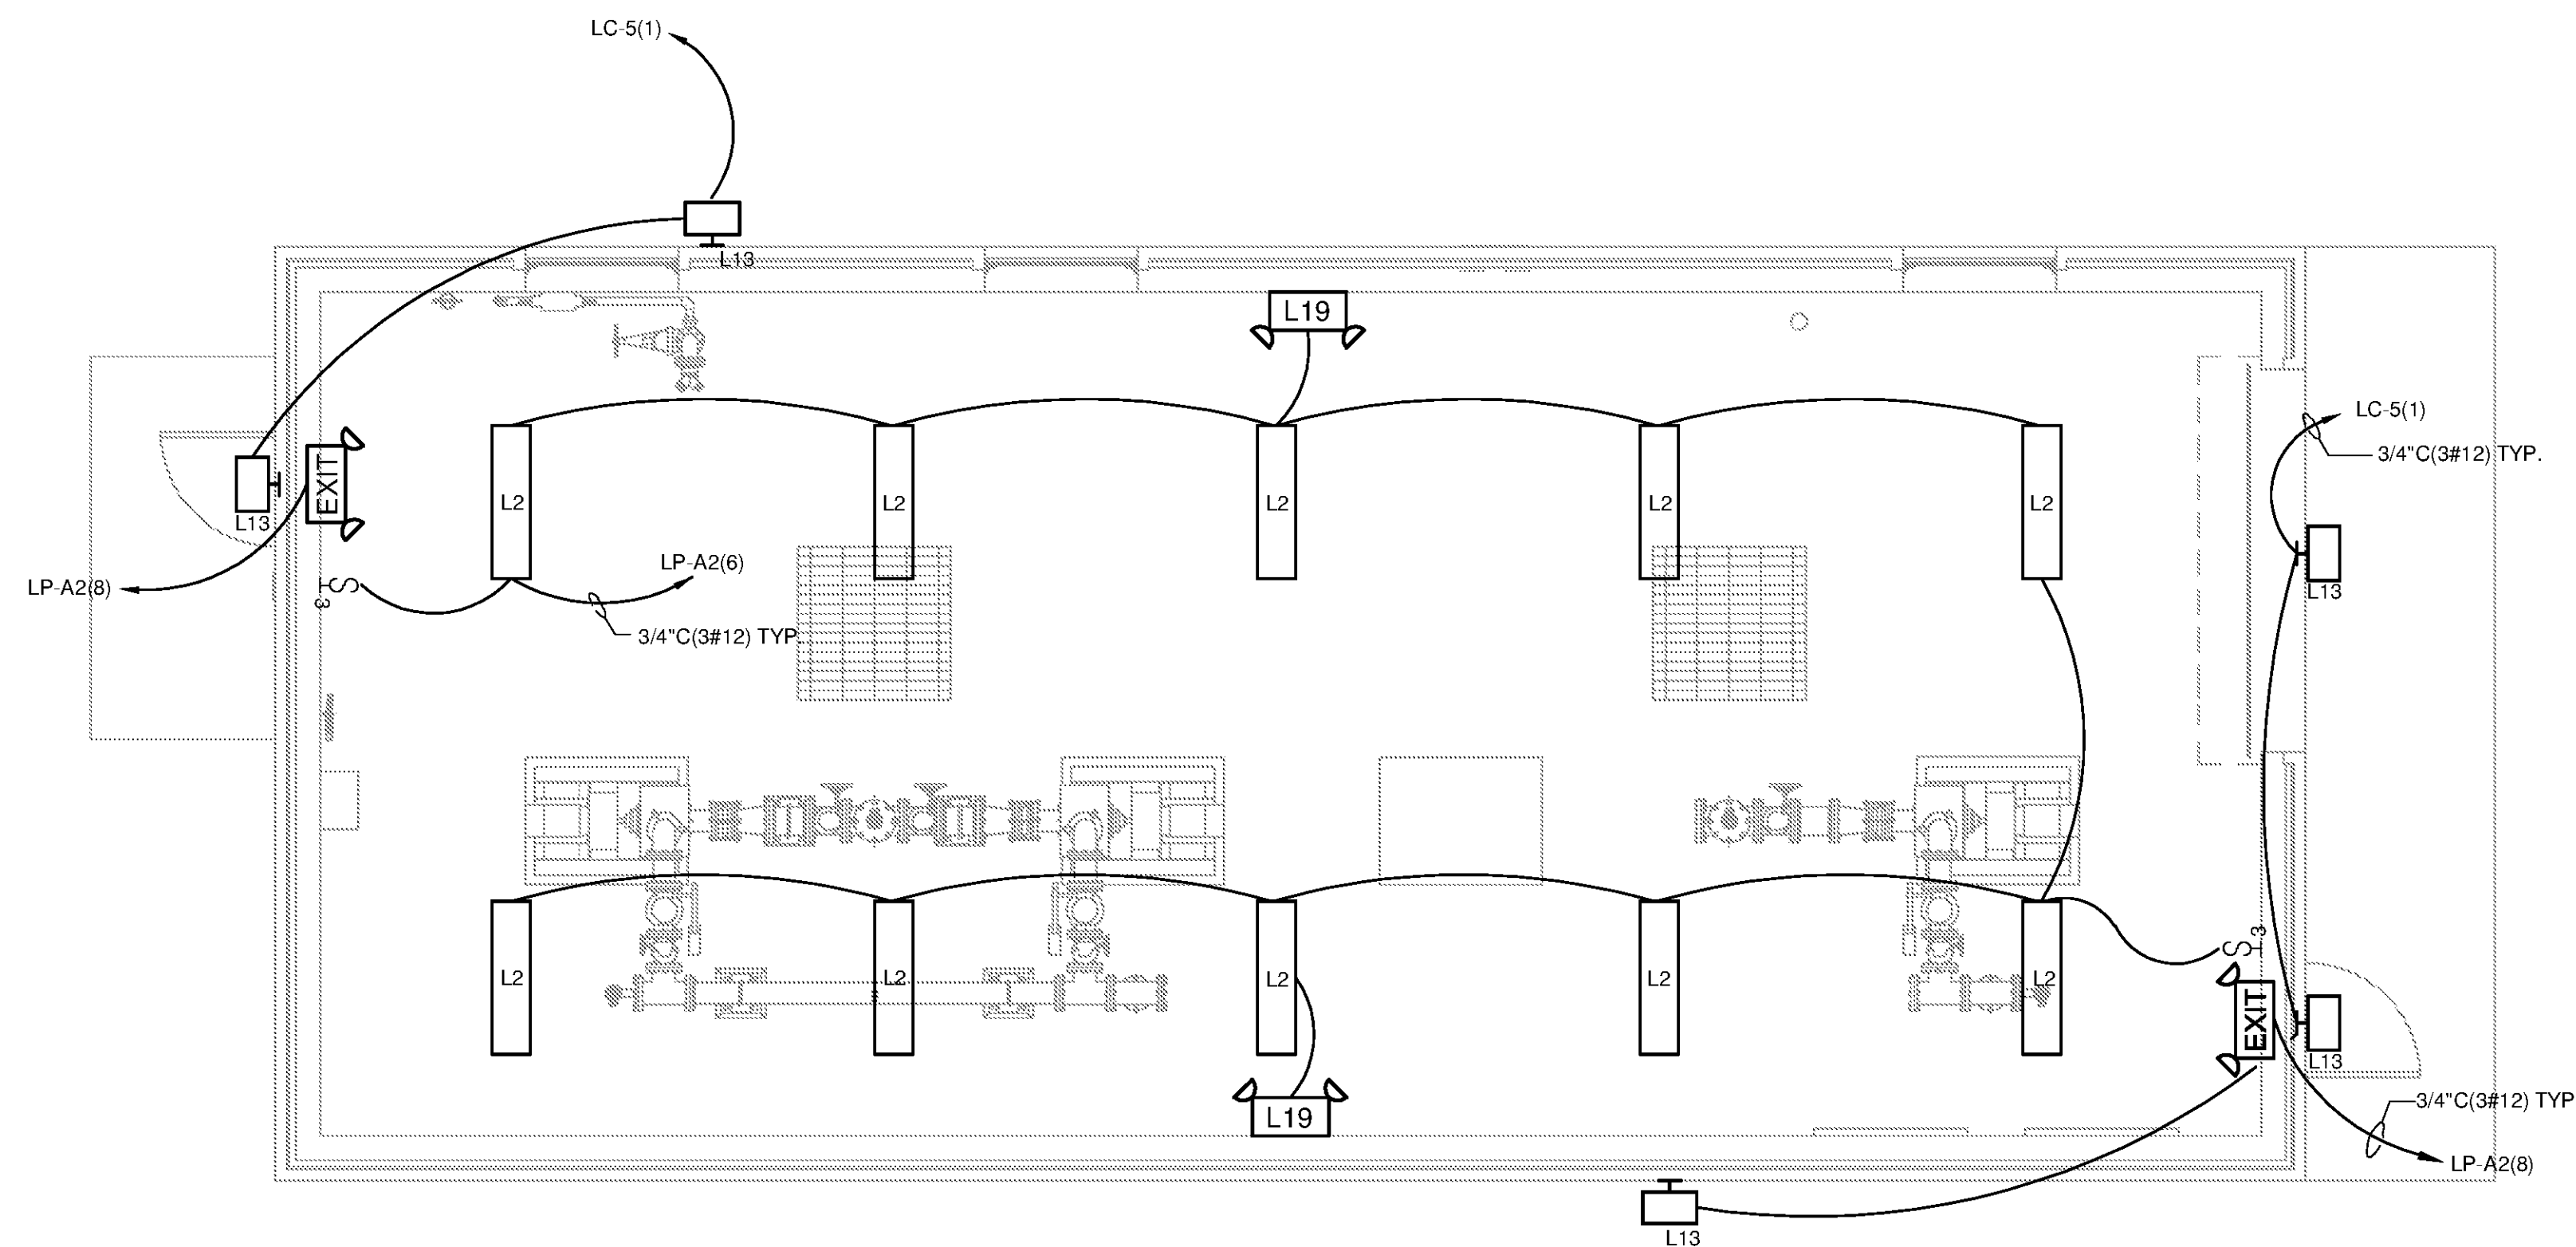


10/17/2014 11:00:57 AM - P:\IER\11740\200-11740-10003\CAD\SHEETFILES\TREATMENT PLANT\WTP E-5402 LIGHTING PLAN - THICKENED SLUDGE RECYCLE PUP STATION.DWG - CALZARETTA, TIMOTHY

F  
E  
D  
C  
B  
A


1 2 3 4 5 6 7

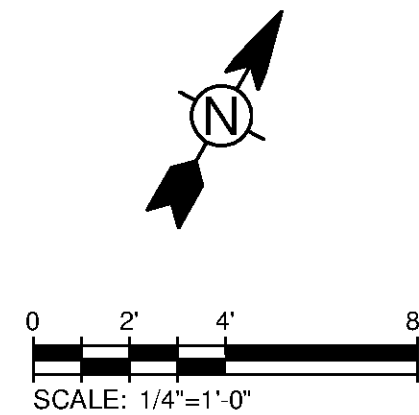

**PLAN**  
SCALE: 1/4"=1'-0"



www.tetrattech.com  
101 QUALITY CIRCLE, SUITE 140  
HUNTSVILLE, ALABAMA 35806  
PHONE: (256) 424-4077 FAX: (256) 424-4097

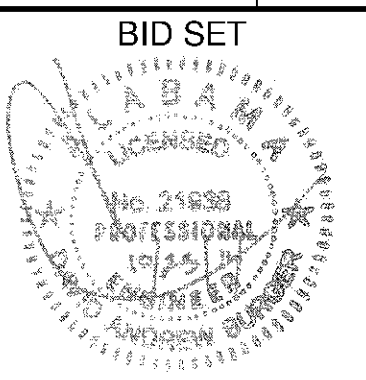

BID SET

MARK	DATE	DESCRIPTION	BY

HUNTSVILLE UTILITIES  
SOUTHEAST WATER TREATMENT PLANT  
**LIGHTING PLAN -  
THICKENED SLUDGE /  
RECYCLE PUMP STATION**

Project No.: 200-11740-10003  
Designed By: CSW  
Drawn By: TAC  
Checked By: DAB

**E-5402**

Copyright: Tetra Tech

Bar Measures 1 inch