


10/17/2014 11:01:37 AM - P:\IER\11740\200-11740-10003\CAD\SHEETFILES\TREATMENT PLANT\WP-E 8402 LIGHTING PLAN - GENERATOR BUILDING.DWG - CALZARETTA, TIMOTHY

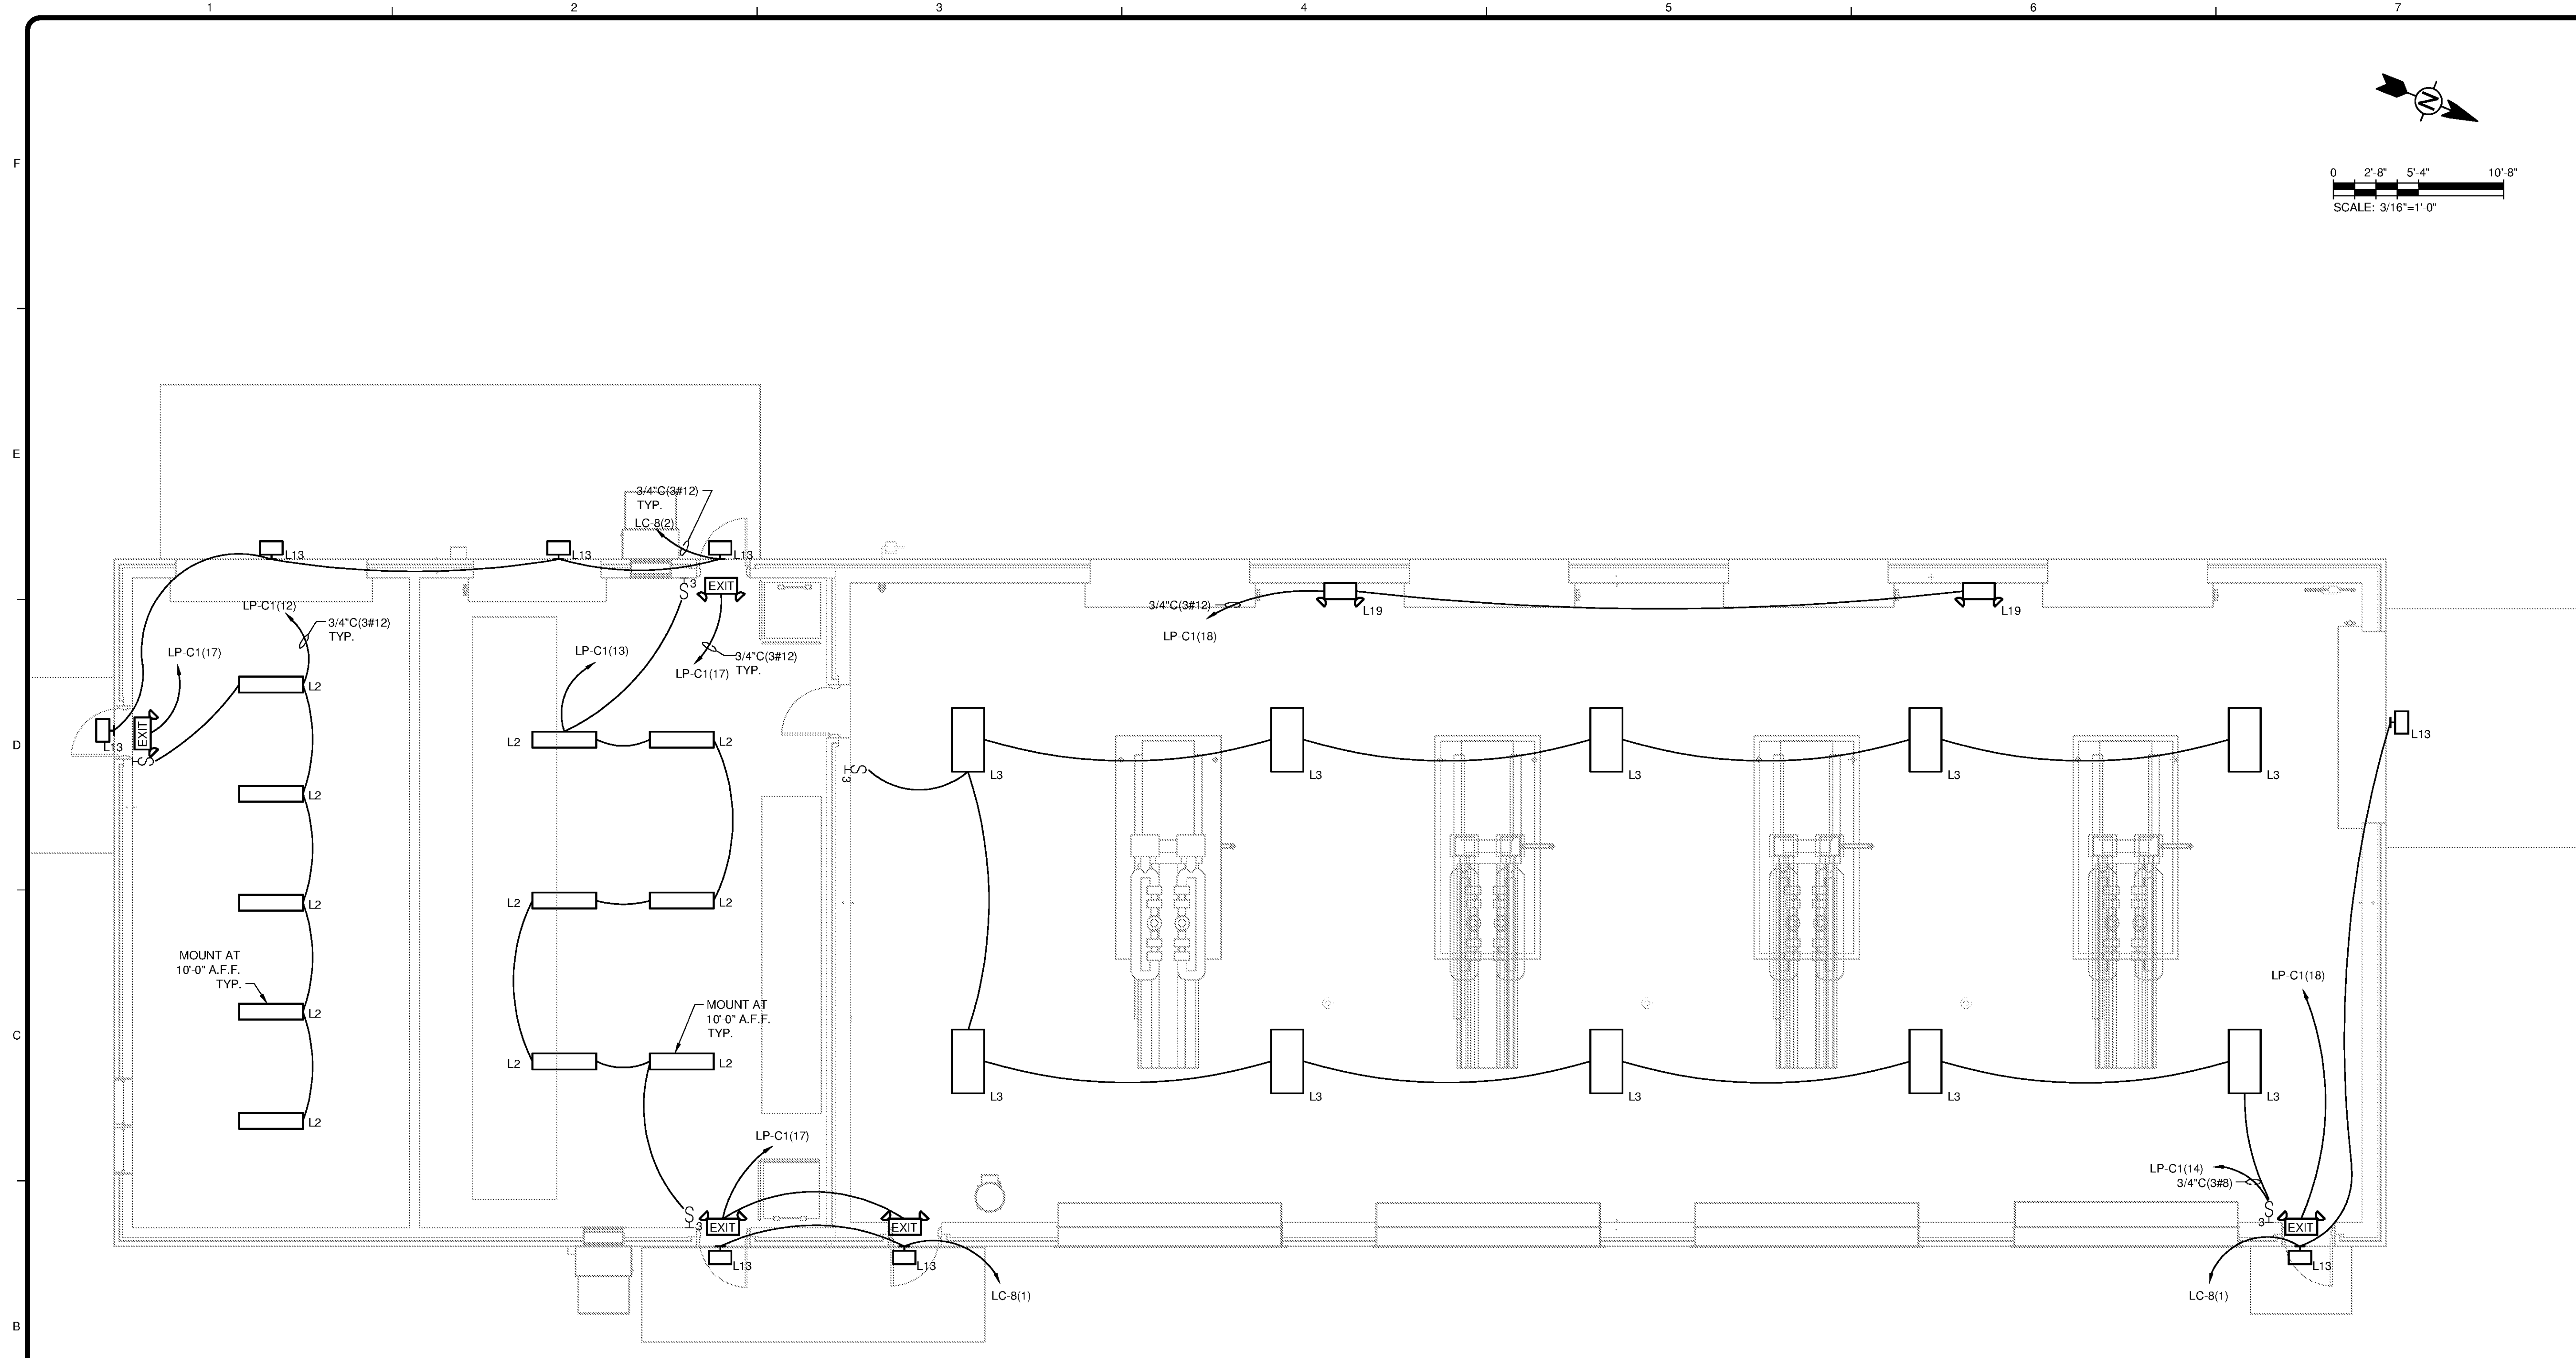

PLAN

SCALE: 3/16"=1'-0"

- NOTES:**
1. INSTALL SEPARATE GROUNDING CONDUCTOR TO EACH CABLE TRAY SECTION. CONNECT FROM CABLE TRAY TO GROUNDING RING/COUNTERPOISE.



BID SET



MARK	DATE	DESCRIPTION	BY

HUNTSVILLE UTILITIES
SOUTHEAST WATER TREATMENT PLANT
**LIGHTING PLAN -
GENERATOR BUILDING**

Project No.: 200-11740-10003
Designed By: CSW
Drawn By: TAC
Checked By: DAB

E-8402

Copyright: Tetra Tech
Bar Measures 1 inch

www.tetrattech.com
101 QUALITY CIRCLE, SUITE 140
HUNTSVILLE, ALABAMA 35806
PHONE: (256) 424-4077 FAX: (256) 424-4097