
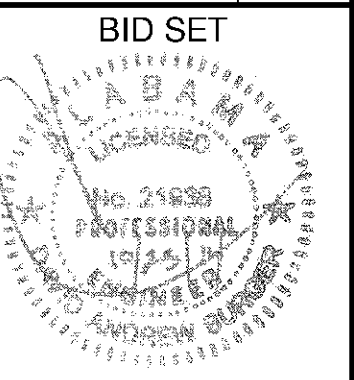


P:\IER\11740\200-11740-10003\CAD\SHHEETFILES\TREATMENT PLANT\WTP E-9520 DETAILS.DWG - CALZARETTA, TIMOTHY

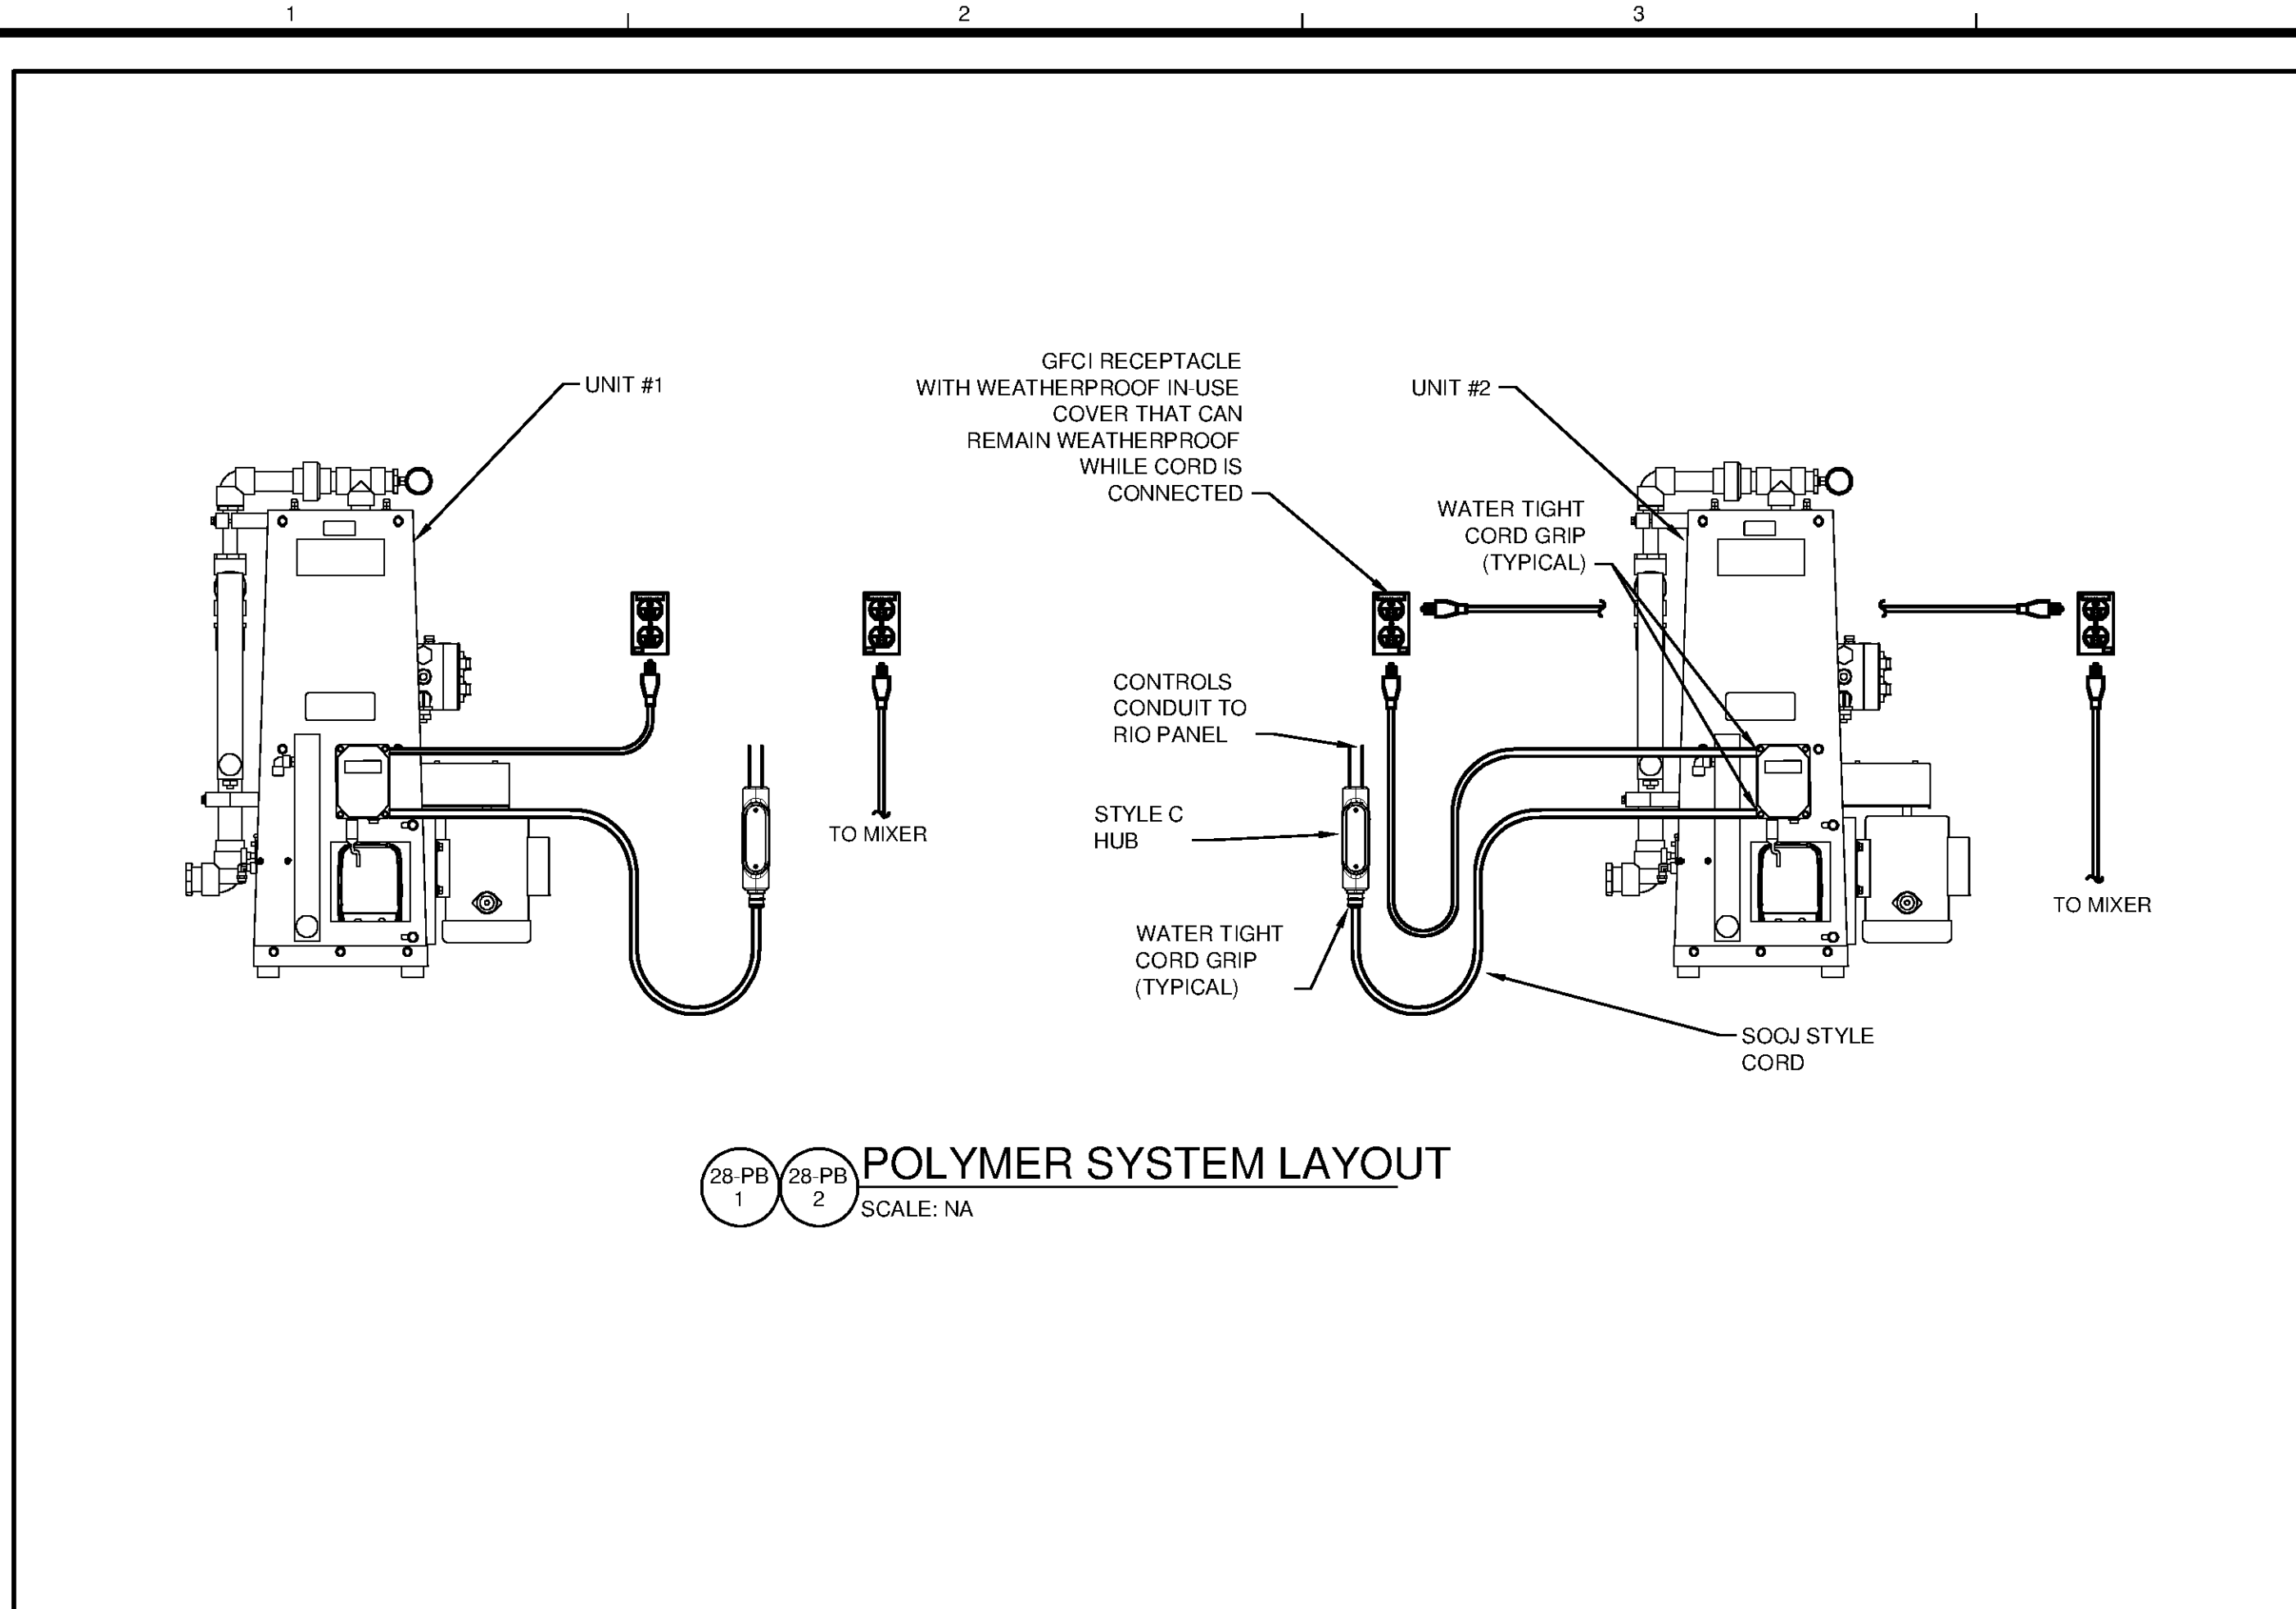

BY	DATE	DESCRIPTION

HUNTSVILLE UTILITIES
SOUTHEAST WATER TREATMENT PLANT

ELECTRICAL DETAILS

Project No.:	200-11740-10003
Designed By:	CSW
Drawn By:	CSW
Checked By:	WAP

E-9522

Bar Measures 1 inch

Copyright: Tetra Tech