



10/17/2014 10:32:15 AM - P:\IER\1740\200-11740-10003\CAD\3SHEET\FILES\TREATMENT PLANT\WTP-10701 PAC PROCESS & INSTRUMENTATION DIAGRAM.DWG - CALZARETTA, TIMOTHY

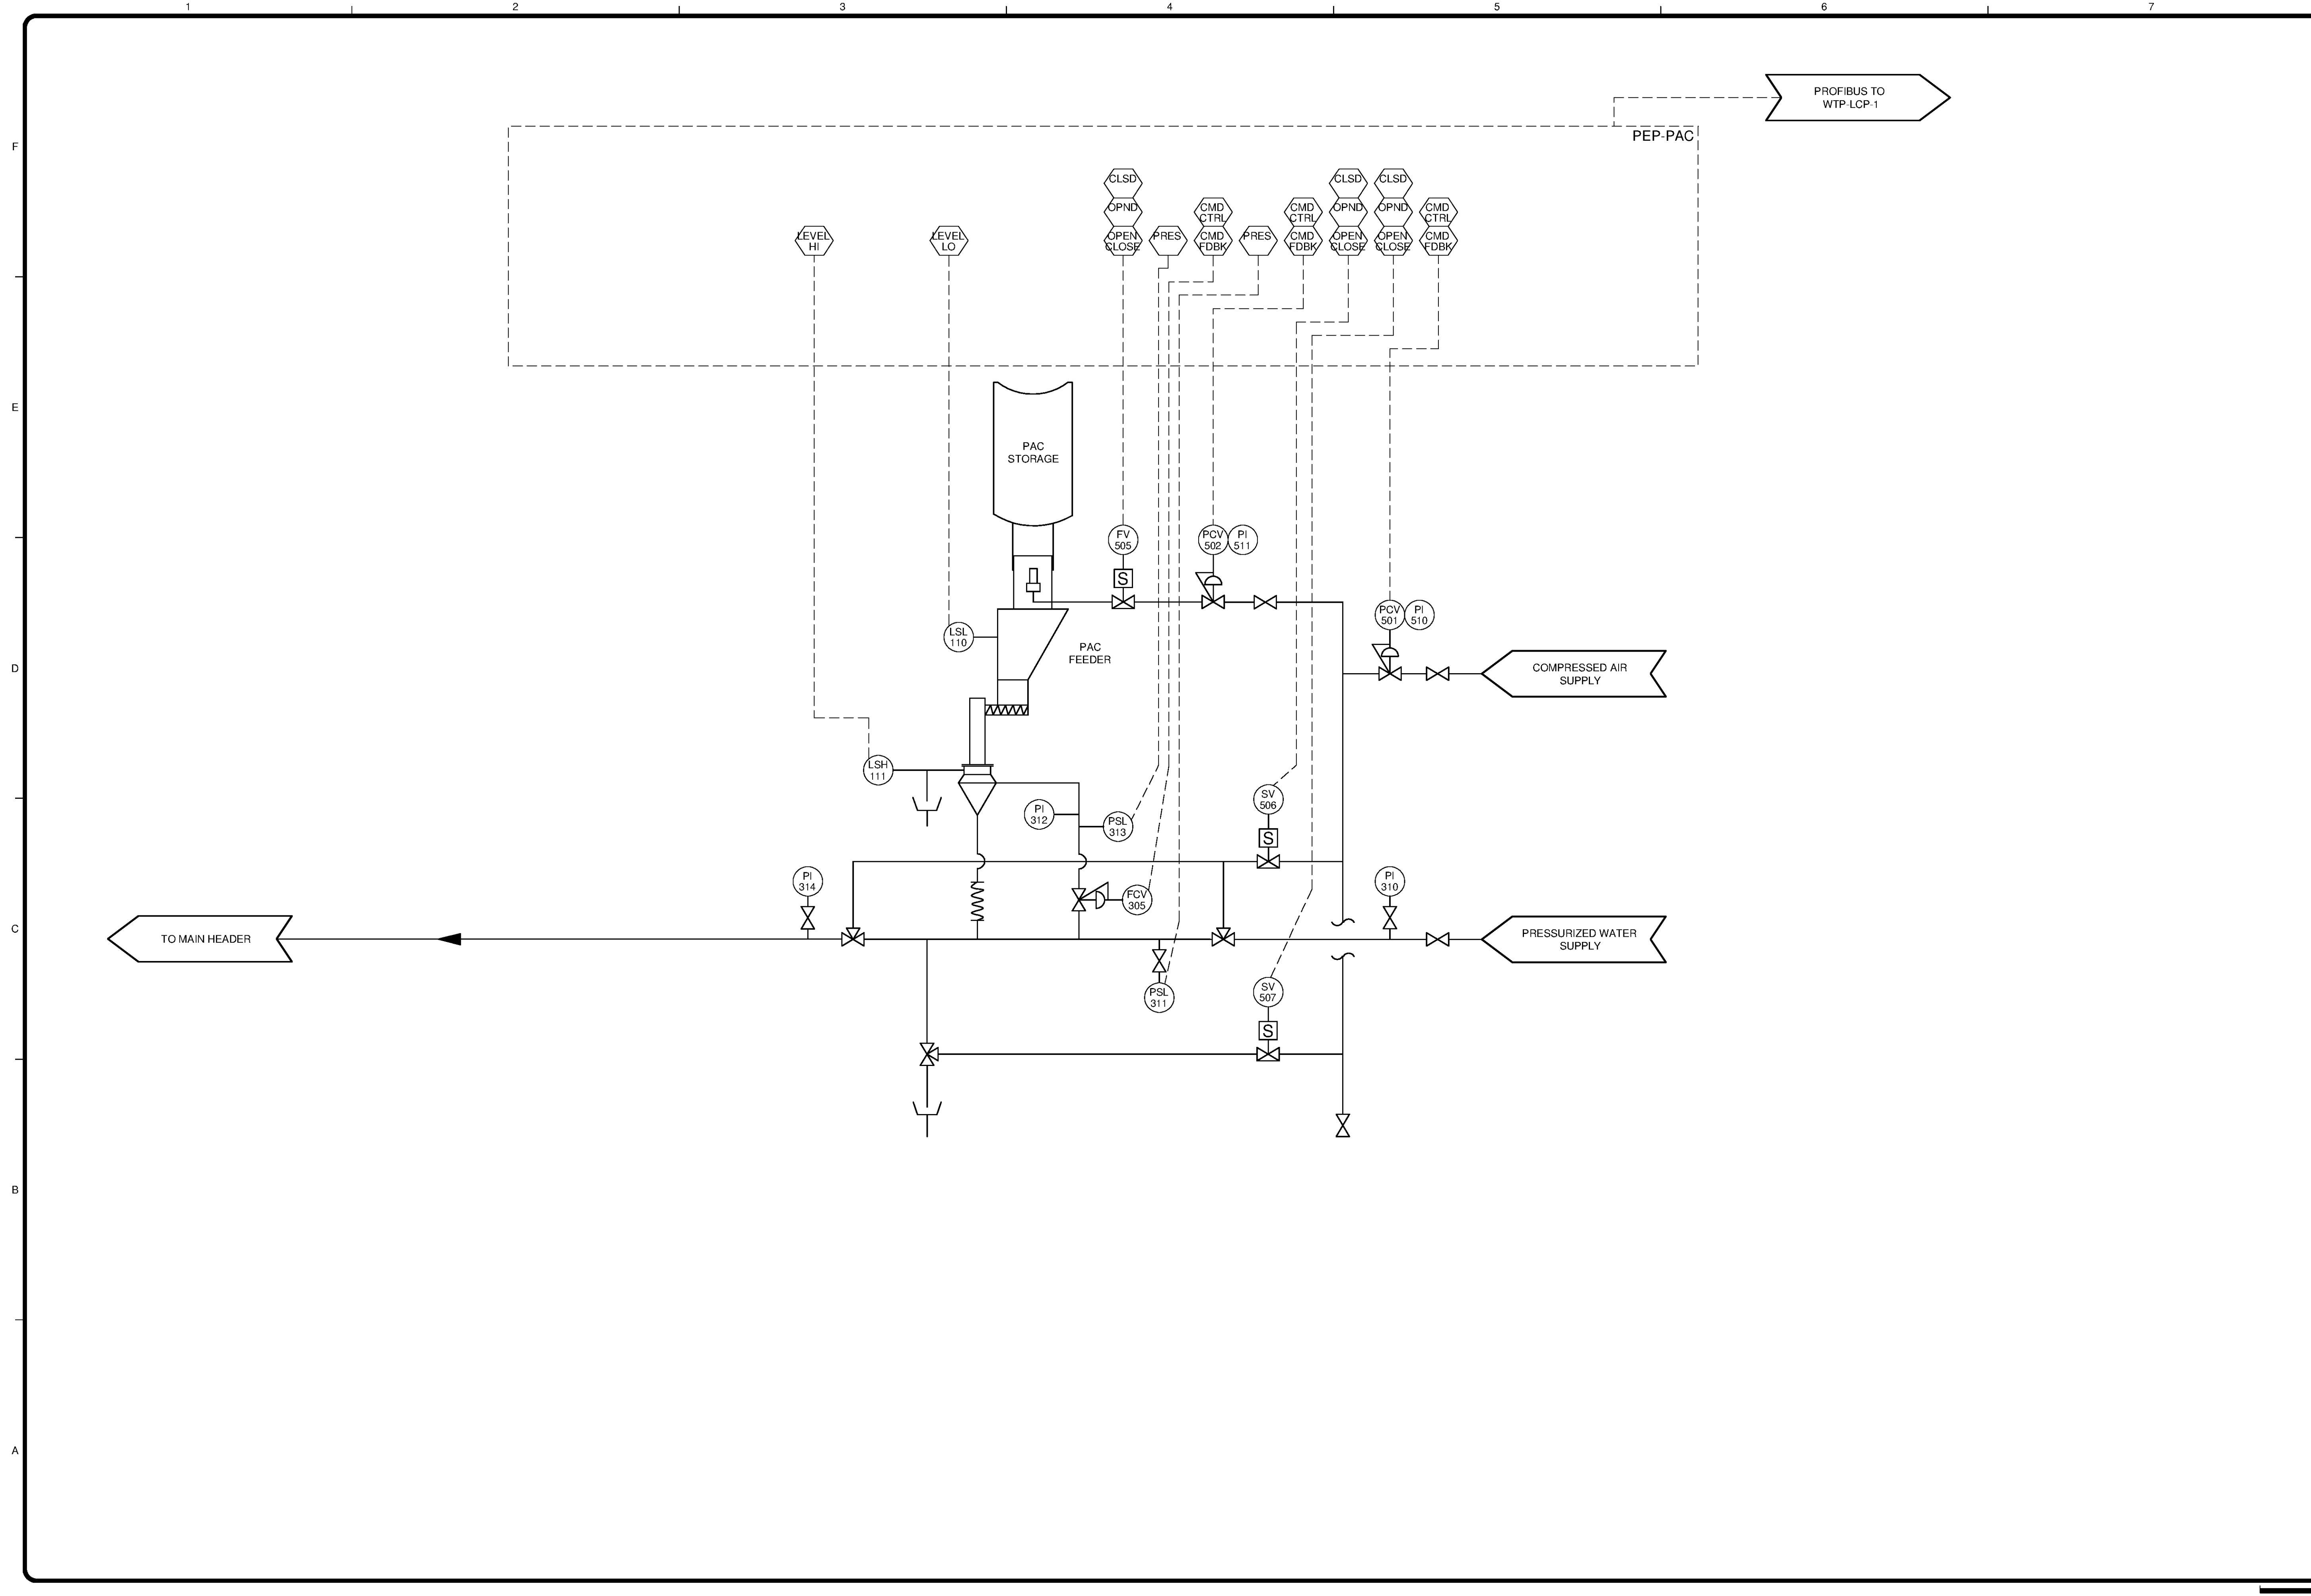

PROFIBUS TO WTP-LCP-1

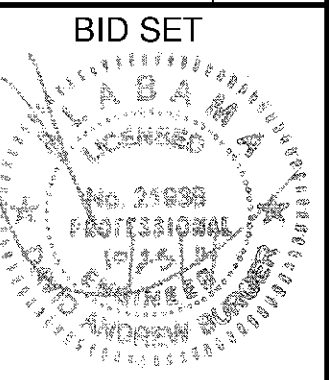

MARK	DATE	DESCRIPTION	BY

HUNTSVILLE UTILITIES
 SOUTHEAST WATER TREATMENT PLANT
PAC SYSTEM
P & ID

Project No.:	200-11740-10003
Designed By:	CSW
Drawn By:	CSW
Checked By:	DAB

I-0701

Copyright Tetra Tech

Bar Measures 1 inch