



10/17/2014 10:38:15 AM - P:\IER\1740\200-11740-10003\CAD\SHEETFILES\TREATMENT PLANT\WTP-I-2700 FLOCCULATION & SEDIMENTATION BASIN P & ID.DWG CALZARETTA, TIMOTHY

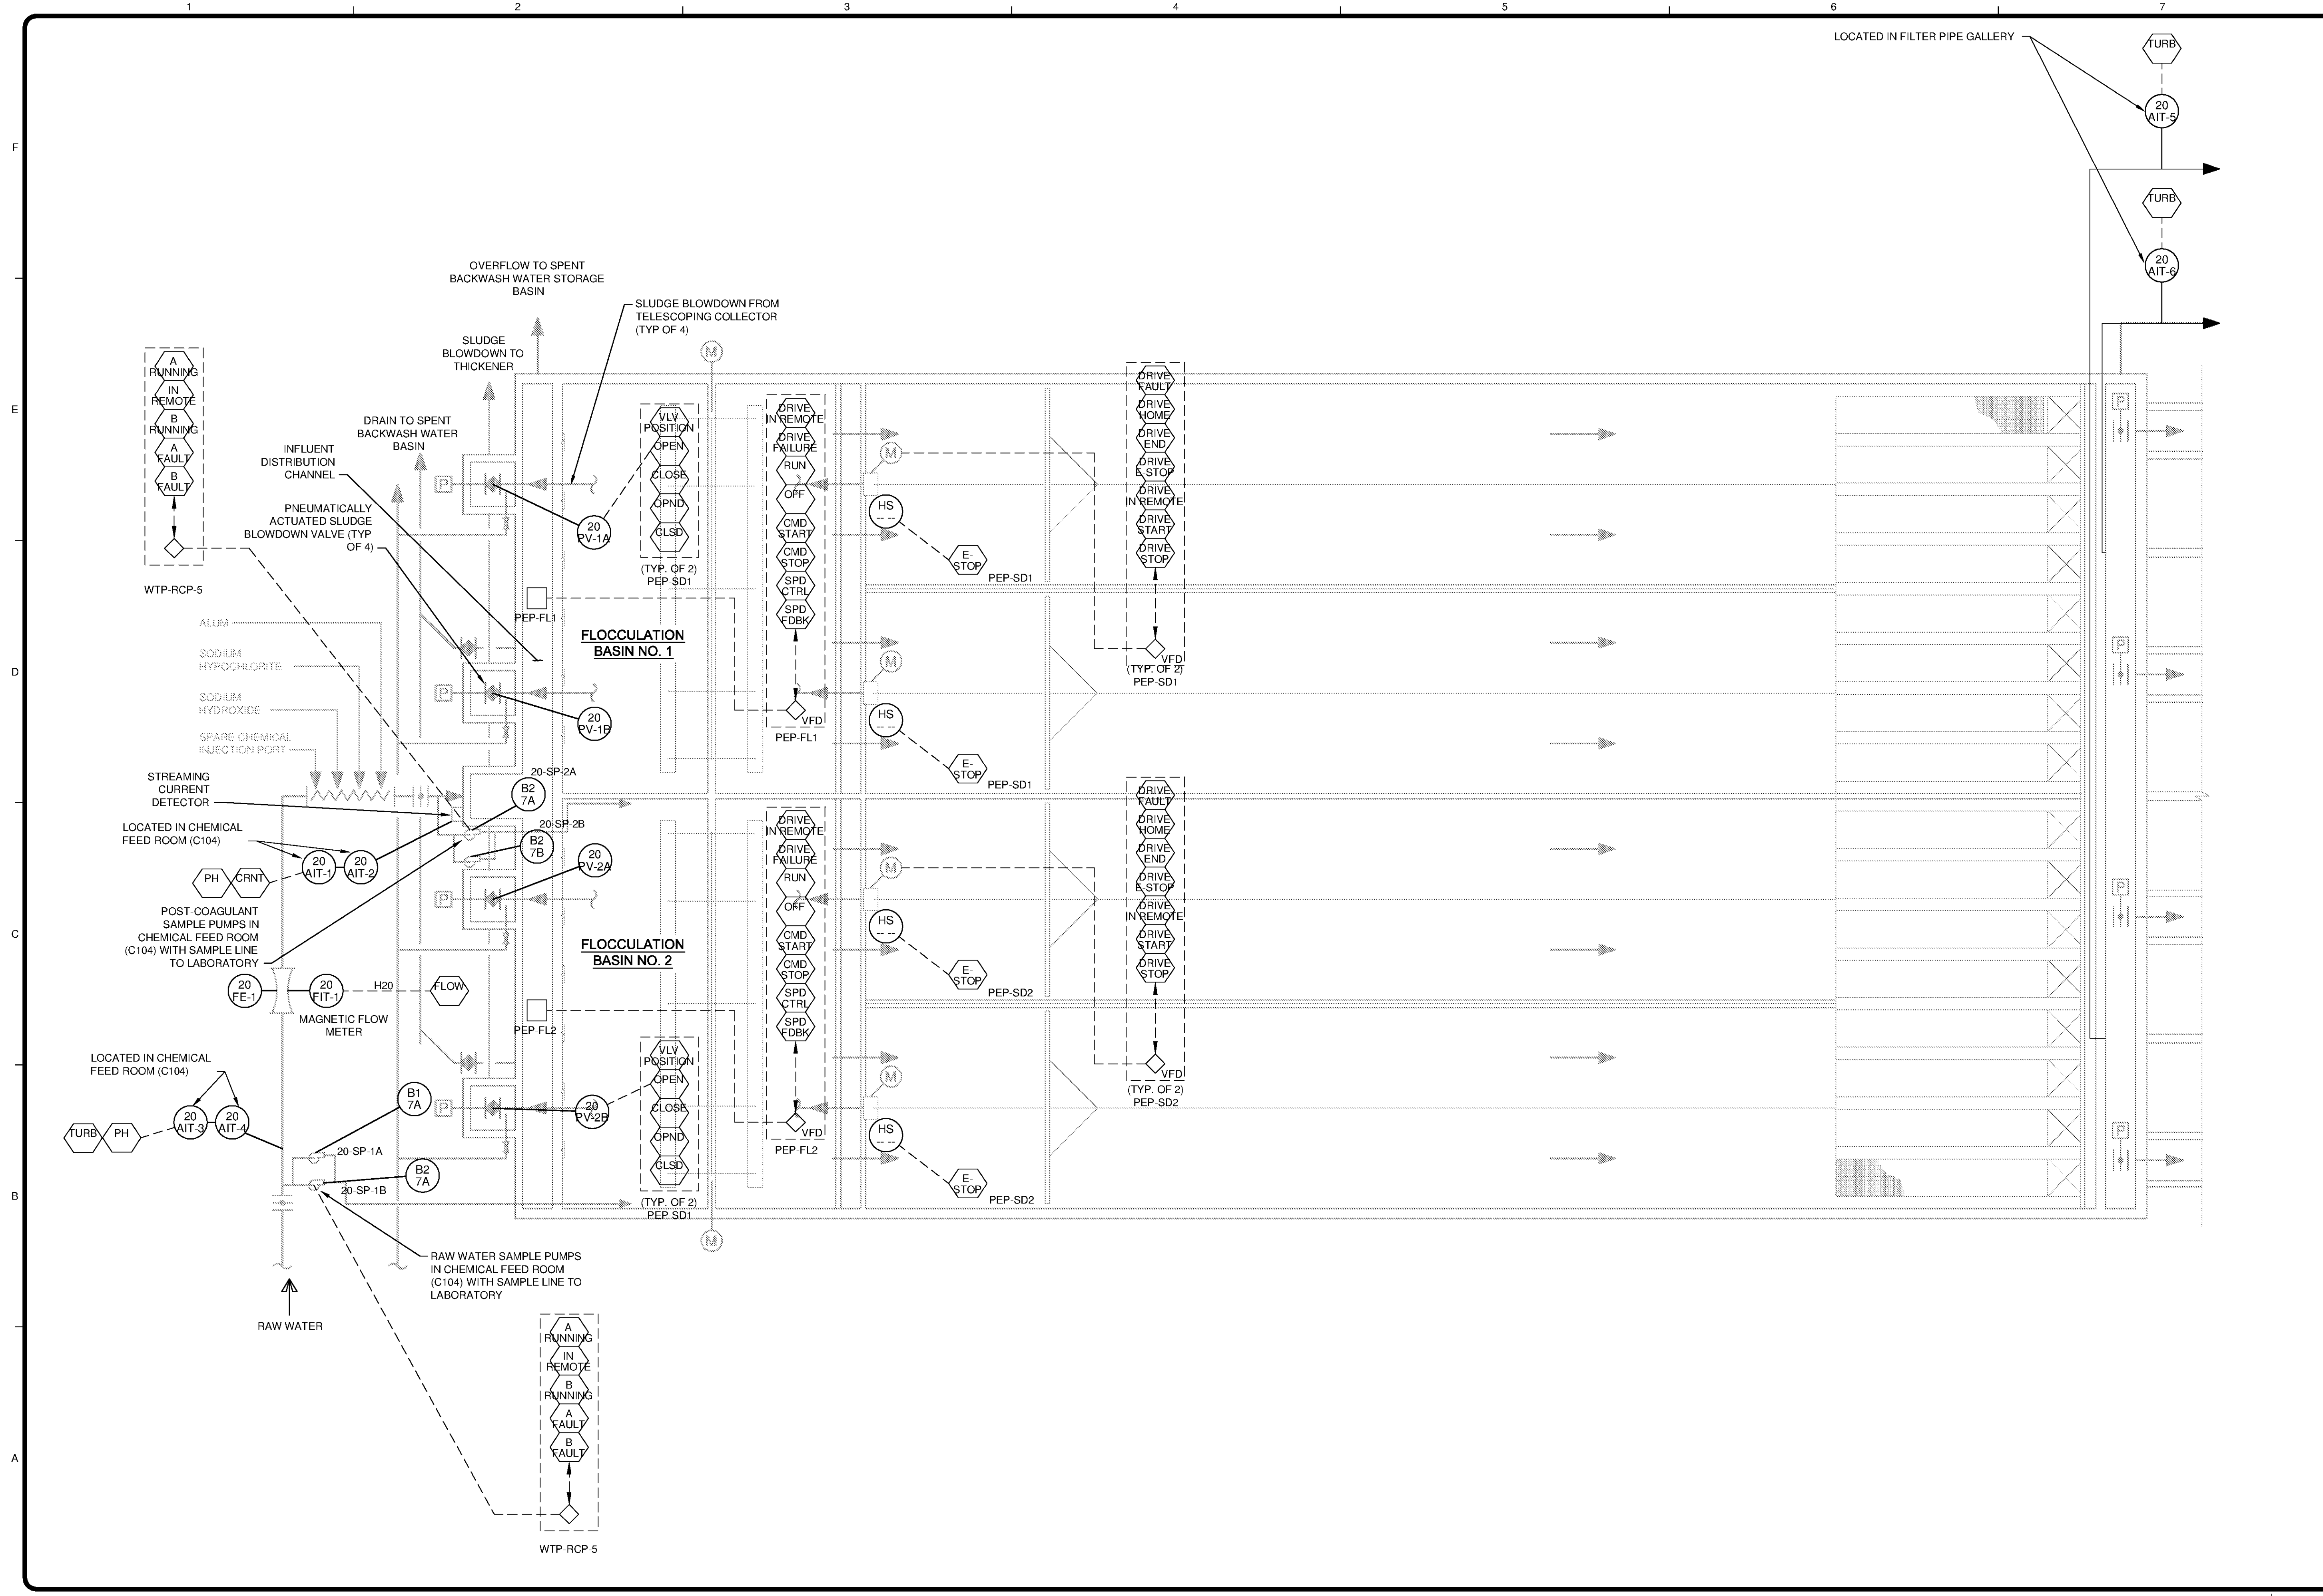

LOCATED IN FILTER PIPE GALLERY

TETRA TECH

www.tetrattech.com
 101 QUALITY CIRCLE, SUITE 140
 HUNTSVILLE, ALABAMA 35806
 PHONE: (256) 424-4077 FAX: (256) 424-4097

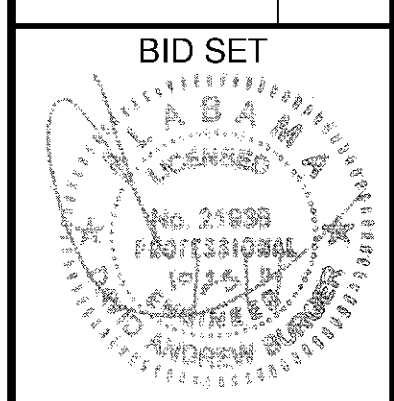

BID SET

MARK	DATE	DESCRIPTION	BY

HUNTSVILLE UTILITIES
 SOUTHEAST WATER TREATMENT PLANT

**FLOCCULATION & SEDIMENTATION BASIN
 P & ID**

Project No.: 200-11740-10003
 Designed By: CSW
 Drawn By: TAC
 Checked By: DAB

I-2700

Copyright: Tetra Tech
 Bar Measures 1 inch