
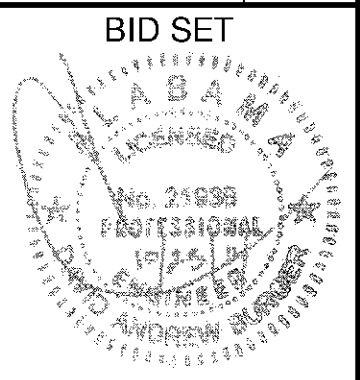


10/17/2014 10:38:45 AM - P:\IER\1740\200-11740-10003\CAD\SHEETFILES\TREATMENT PLANT\WTP-1-4700 FINISHED WATER PROCESS & INSTRUMENTATION DIAGRAM.DWG - CALZARETTA, TIMOTHY

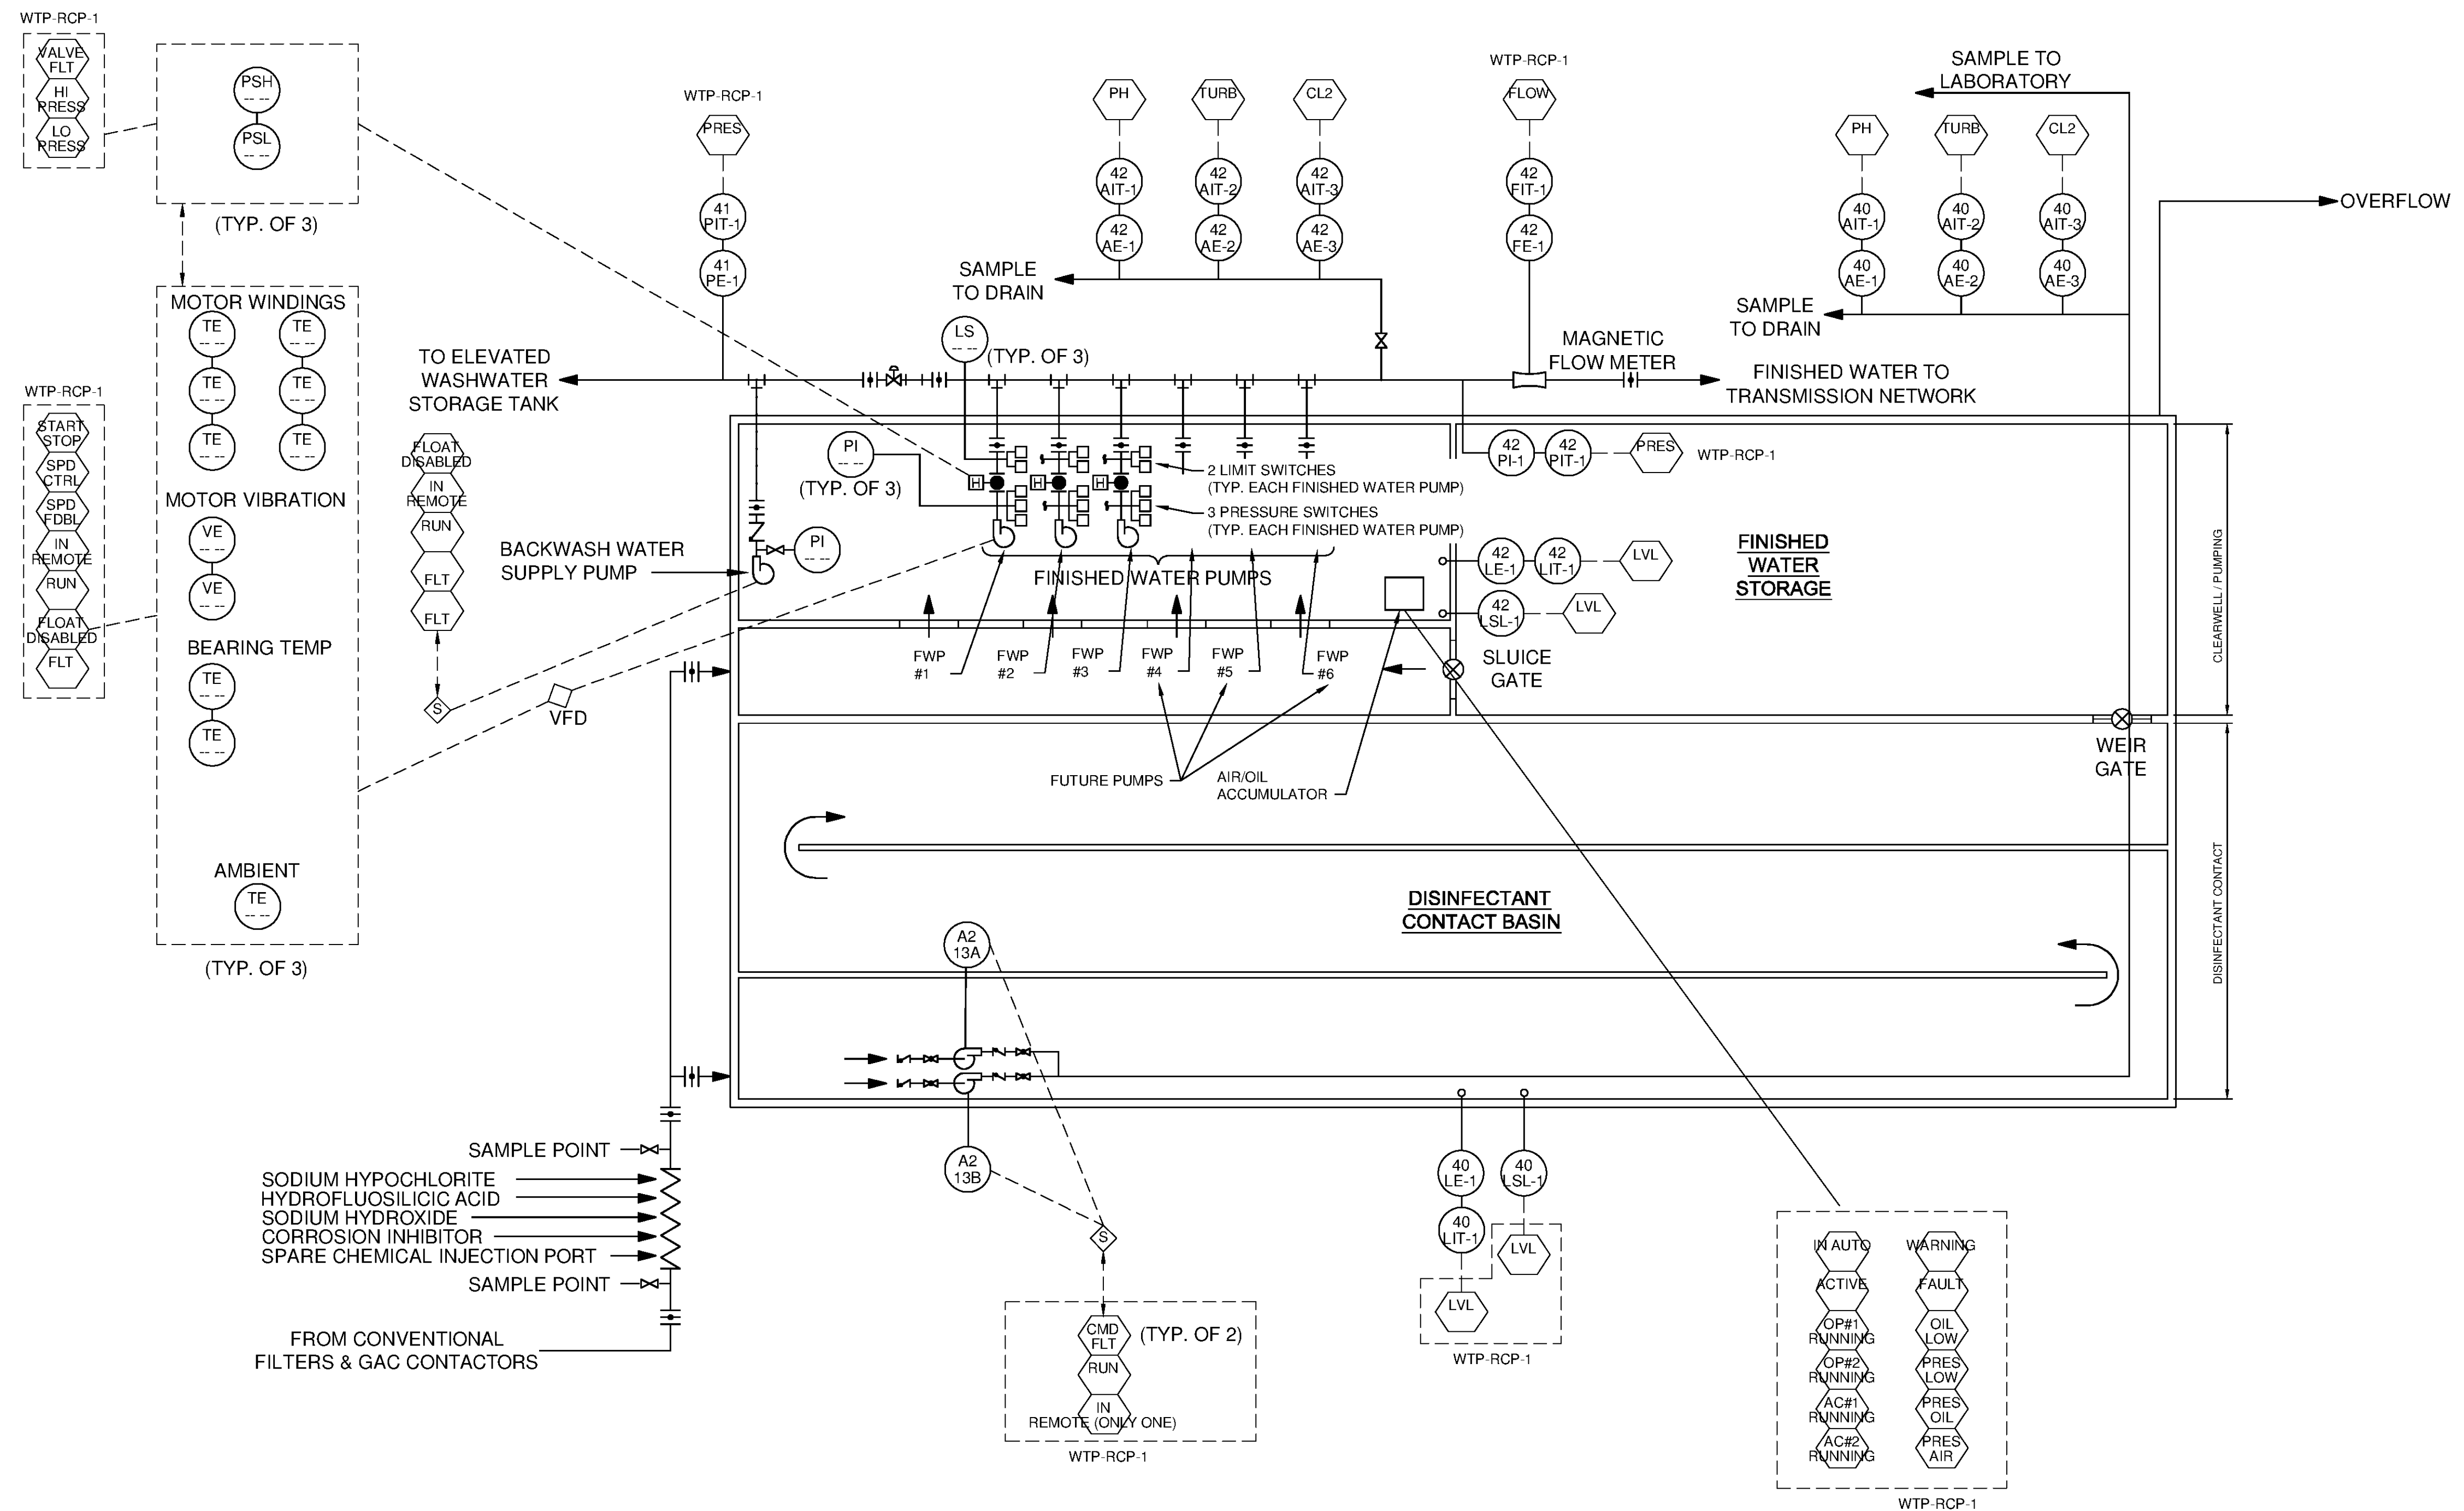

BID SET

BY	
DATE	
DESCRIPTION	
MARK	

BY	
DATE	
DESCRIPTION	
MARK	

HUNTSVILLE UTILITIES
SOUTHEAST WATER TREATMENT PLANT
**FINISHED WATER
STORAGE & PUMPING
P & ID**

Project No.: 200-11740-10003
Designed By: CSW
Drawn By: TAC
Checked By: DAB

I-4700