

PHASE 3


PHASE 1

PHASE 3

DUMPSTER PAD

ALTERNATE - GRAVEL LAYDOWN AREA

PHASE 2 - Fuel Island

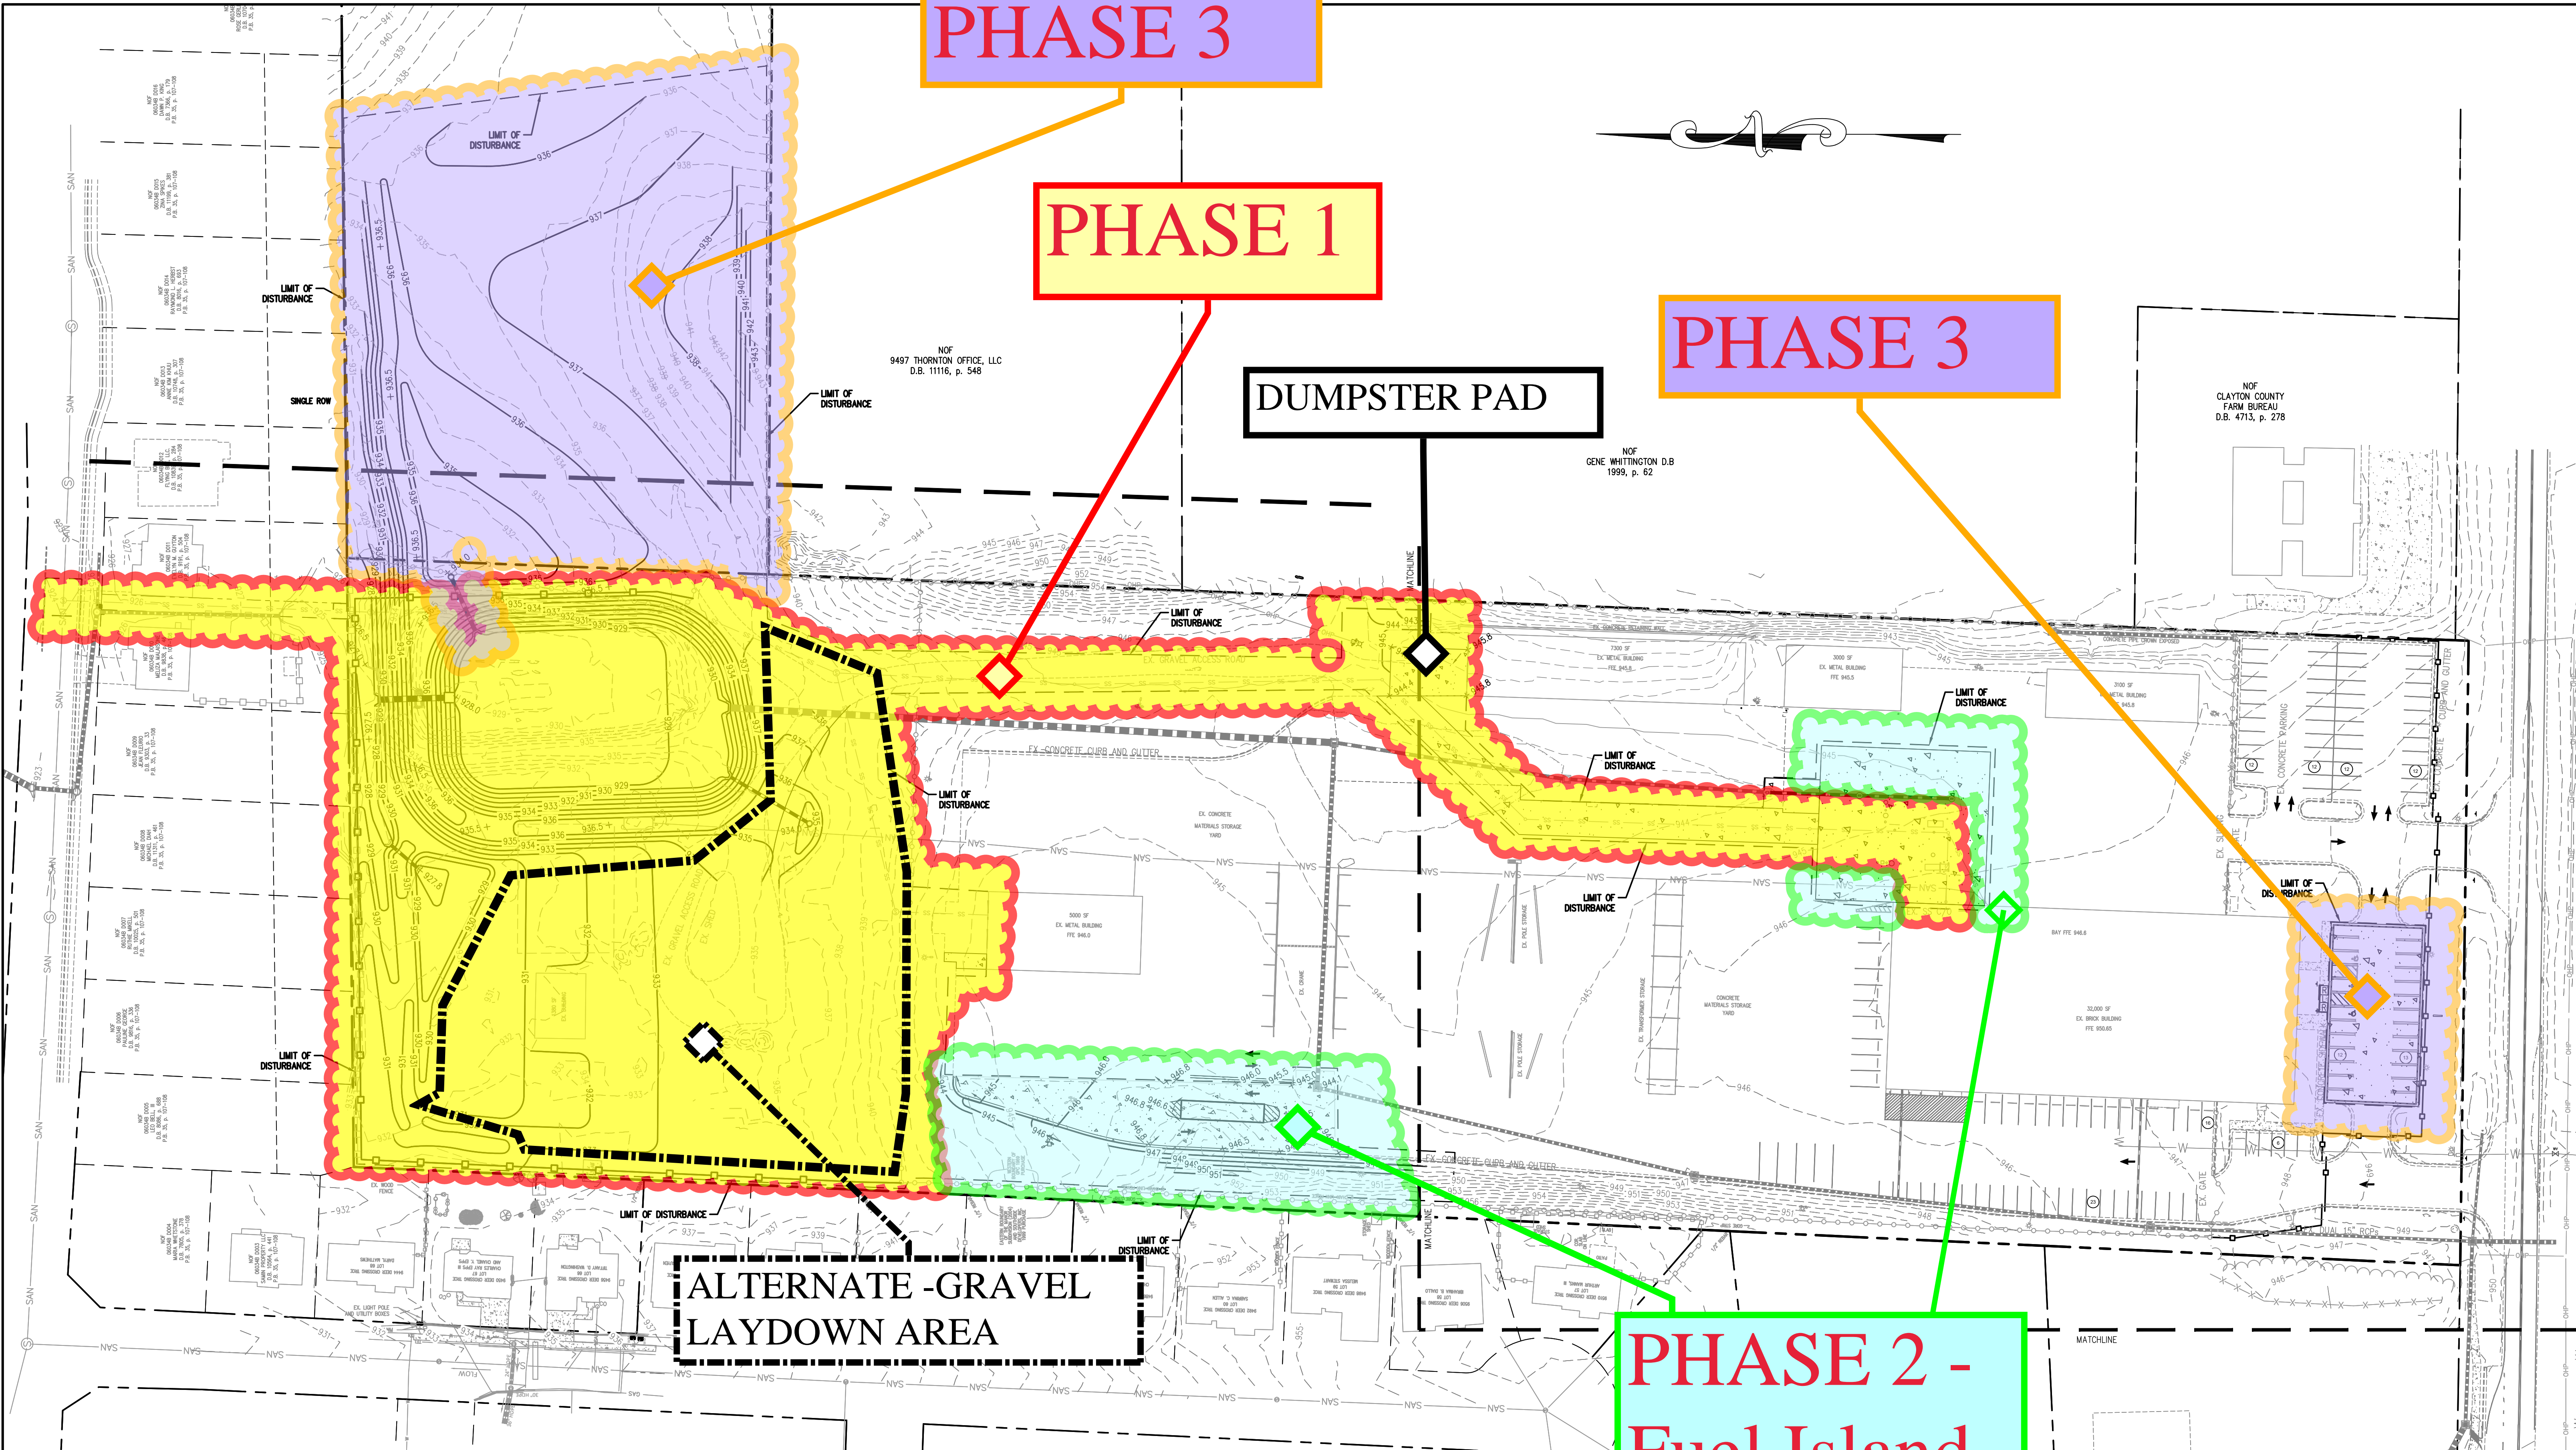

**LEGEND**

--- (dashed line)	PROPOSED LIMITS OF DISTURBANCE
--- (solid line)	PROPERTY/RIGHT-OF-WAY LINE
--- (dashed line)	PROPOSED STORM PIPE
--- (dotted line)	EXISTING GRADE
--- (solid line)	PROPOSED GRADE
■ (square)	SPOT GRADE

**LEGEND:**

JB	- JUNCTION BOX
DI	- GRATE INLET
PI	- PEDESTAL INLET
OCS	- OUTLET CONTROL STRUCTURE
HW	- HEADWALL
SES	- SAFETY END SECTION
RCP	- REINFORCED CONCRETE PIPE
HDPE	- HIGH DENSITY POLYETHYLENE PIPE

**OWNER**  
**GEORGIA POWER COMPANY**  
 241 RALPH MACLELLAN BOULEVARD NE  
 BIN 10221  
 ATLANTA, GA 30308  
 CONTACT: BARRY WETHERINGTON  
 (404) 506-2533

**OPERATOR / 24 HOUR CONTACT**  
 241 RALPH MACLELLAN BOULEVARD NE  
 BIN 10041  
 ATLANTA, GA 30308-3374  
 CONTACT: BRYAN HARRIS  
 (404) 506-4932

**ENGINEER**  
**AEC, INC.**  
 50 WARM SPRING CIRCLE  
 ROSWELL, GA 30075  
 CONTACT: MARK VAN DE WATER  
 (770) 641-1942  
 LEVEL II CERT. # 6960



Scale 1" = 50'

**GEORGIA811**  
 Utilities Protection Center, Inc.  
 Know what's below.  
 Call before you dig.  
 Dial 811 or Call 1-800-282-7411

AEC JOB # 18-4190.20

**GEORGIA POWER CO., ATLANTA, GA.  
 LAND DEPARTMENT**

**GPC NOAHS ARK OPERATING HEADQUARTERS**

**OVERALL GRADING & DRAINAGE PLAN**  
 CLAYTON COUNTY, GEORGIA

DR.	MDA	TR.	CHK
			CJW/MDV
SCALE	1" = 50'	DATE	5/17/2019
DRAWING No.		SHEET No.	9 OF 30

APPROVALS

NO.	DATE	BY

4.0E/3/20 CWM ADDED DUMPSTER PAD AREA  
 3.0E/7/14/20 CWM MASTER SITE IMPROVEMENT SET  
 2.0E/7/31/20 CWM REV. SEWER TIE IN LOCATION  
 1.0E/7/13/19 MDV REV. SEWER TIE IN LOCATION