


This document, together with the concepts and designs presented herein, is intended only for the specific purpose and client for which it was prepared. Reuse of and improper reliance on this document without written authorization and adaptation by Kimley-Horn and Associates, Inc. shall be without liability to Kimley-Horn and Associates, Inc.

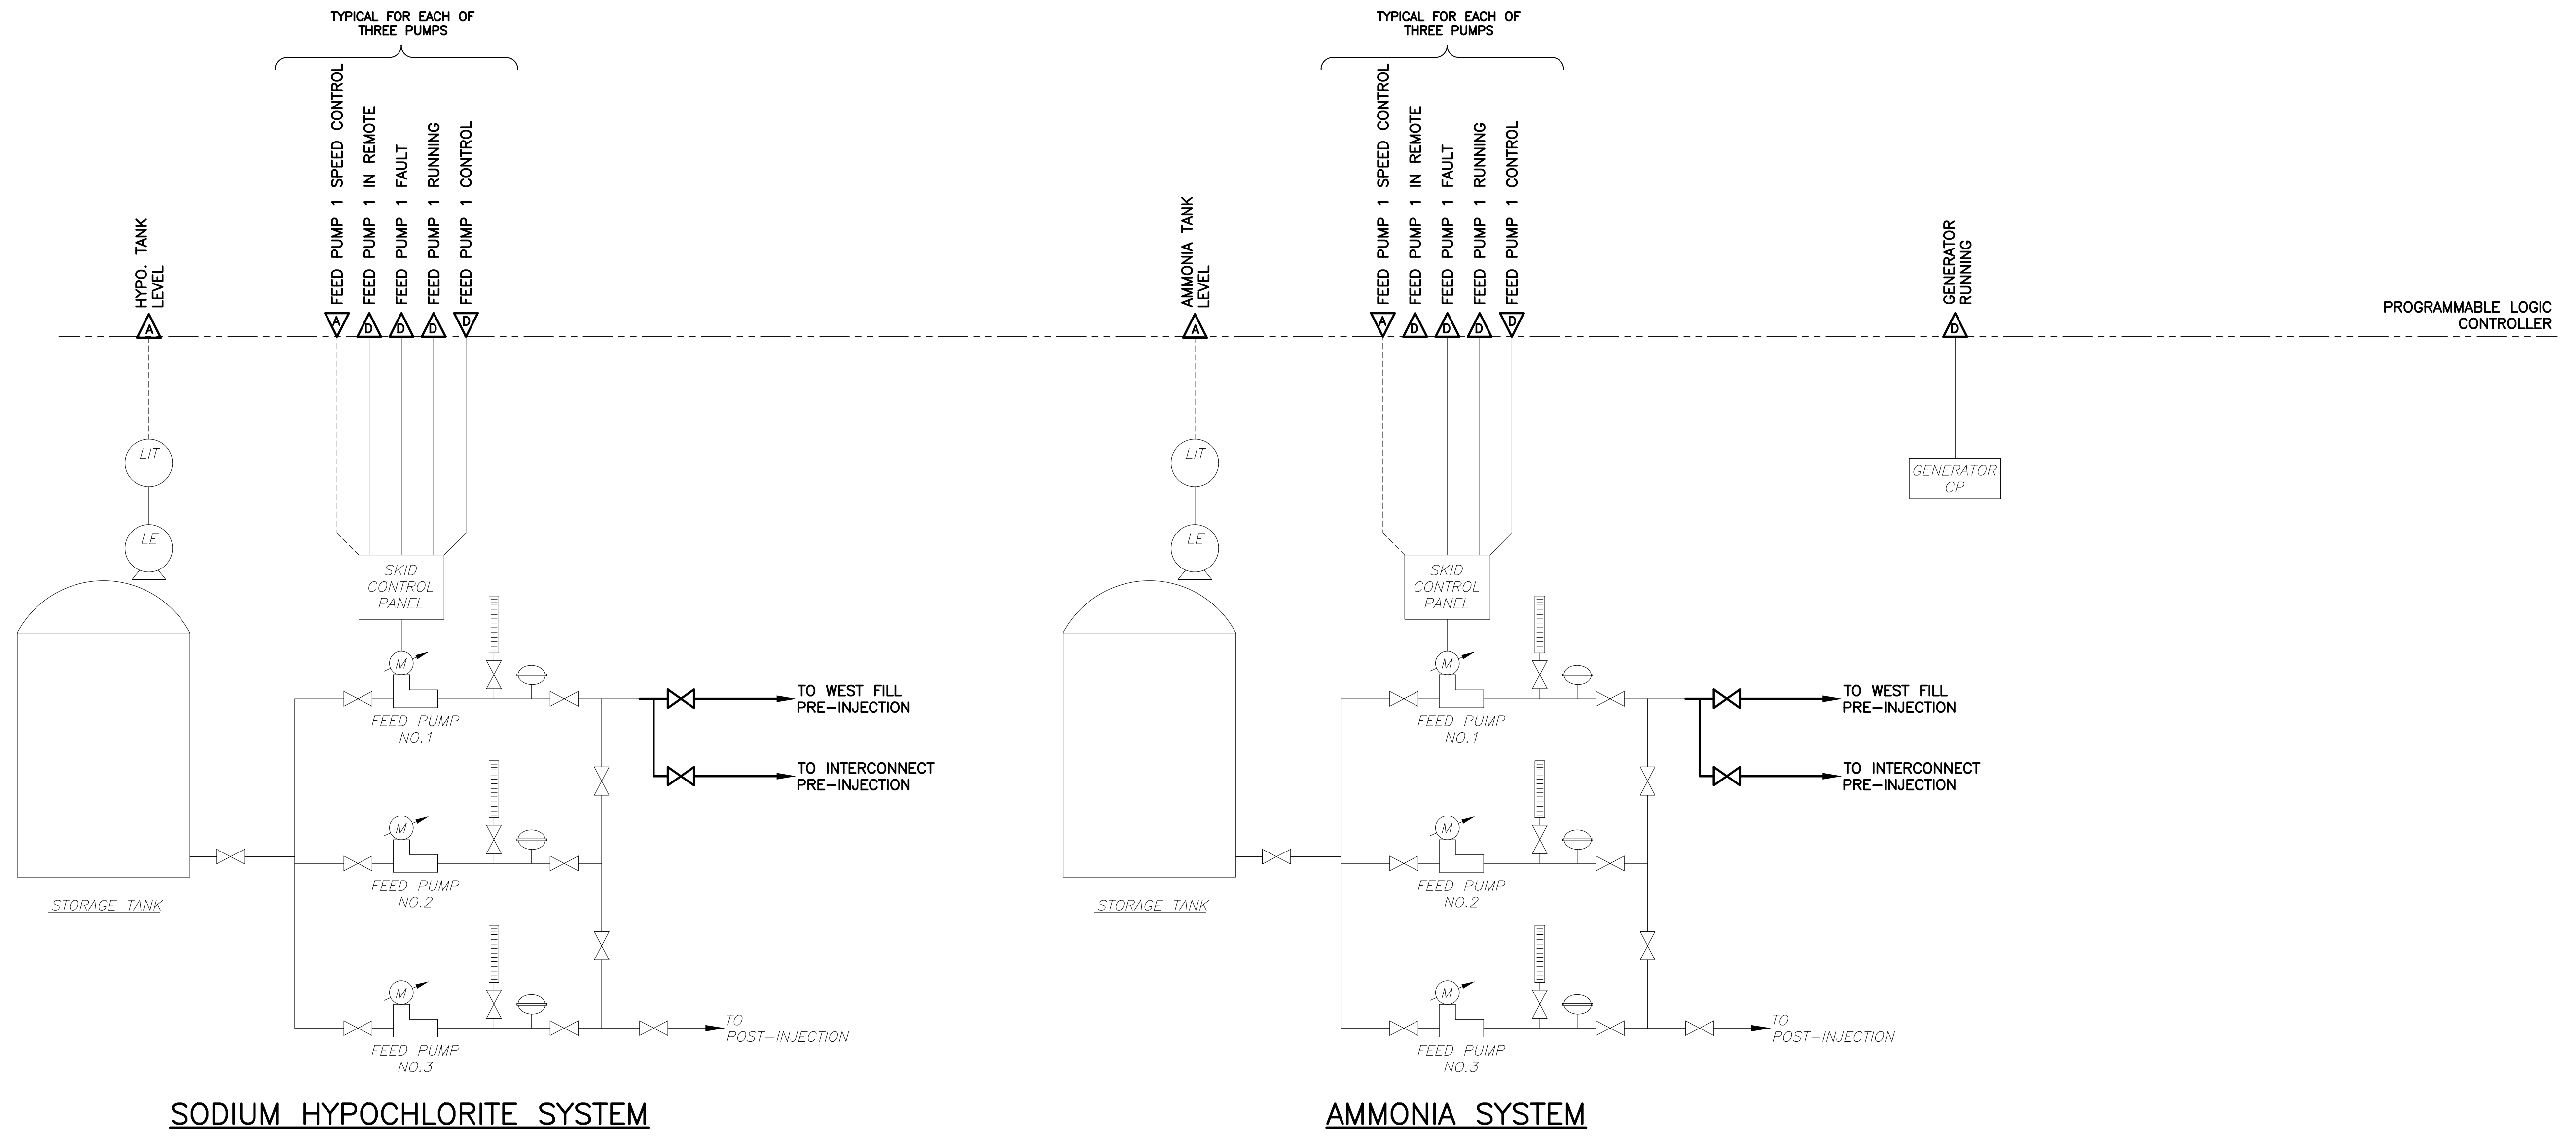

X:\Active Projects\Kimley-Horn\Sarasota County Peace River PS & SUG\_Bidset\Design\03 P&ID - CHEM.dwg 4/24/2020 2:57:39 PM, dmanth

10620 GRIFFIN ROAD, SUITE 202  
 COOPER CITY, FLORIDA 33328  
 PHONE: (954) 448-7930  
 C.O.A. NO. 6783  
 Stephen E. Bailey, P.E.  
 Florida P.E. No. 42461



**BIDSET SUBMITTAL**

No.	REVISIONS	DATE	BY

**Kimley»Horn**

1777 MAIN STREET, SUITE 200, SARASOTA, FL 34236  
 PHONE: 941-379-7600  
 WWW.KIMLEY-HORN.COM CA 00000696

KHA PROJECT

DATE  
4/24/20

SCALE: AS NOTED

DESIGNED BY SEB

DRAWN BY SJL

CHECKED BY SEB

**Sarasota County**

**PEACE RIVER INTERCONNECT AND POTABLE WATER TRANSMISSION MAIN**

SARASOTA COUNTY

LICENSED PROFESSIONAL

STEPHEN E. BAILEY, P.E.

42461

FL DATE:

**P&ID CHEMICALS**

SHEET NUMBER

**I-03**