



1 2 3 4 5 6 7 8


F
E
D
C
B
A

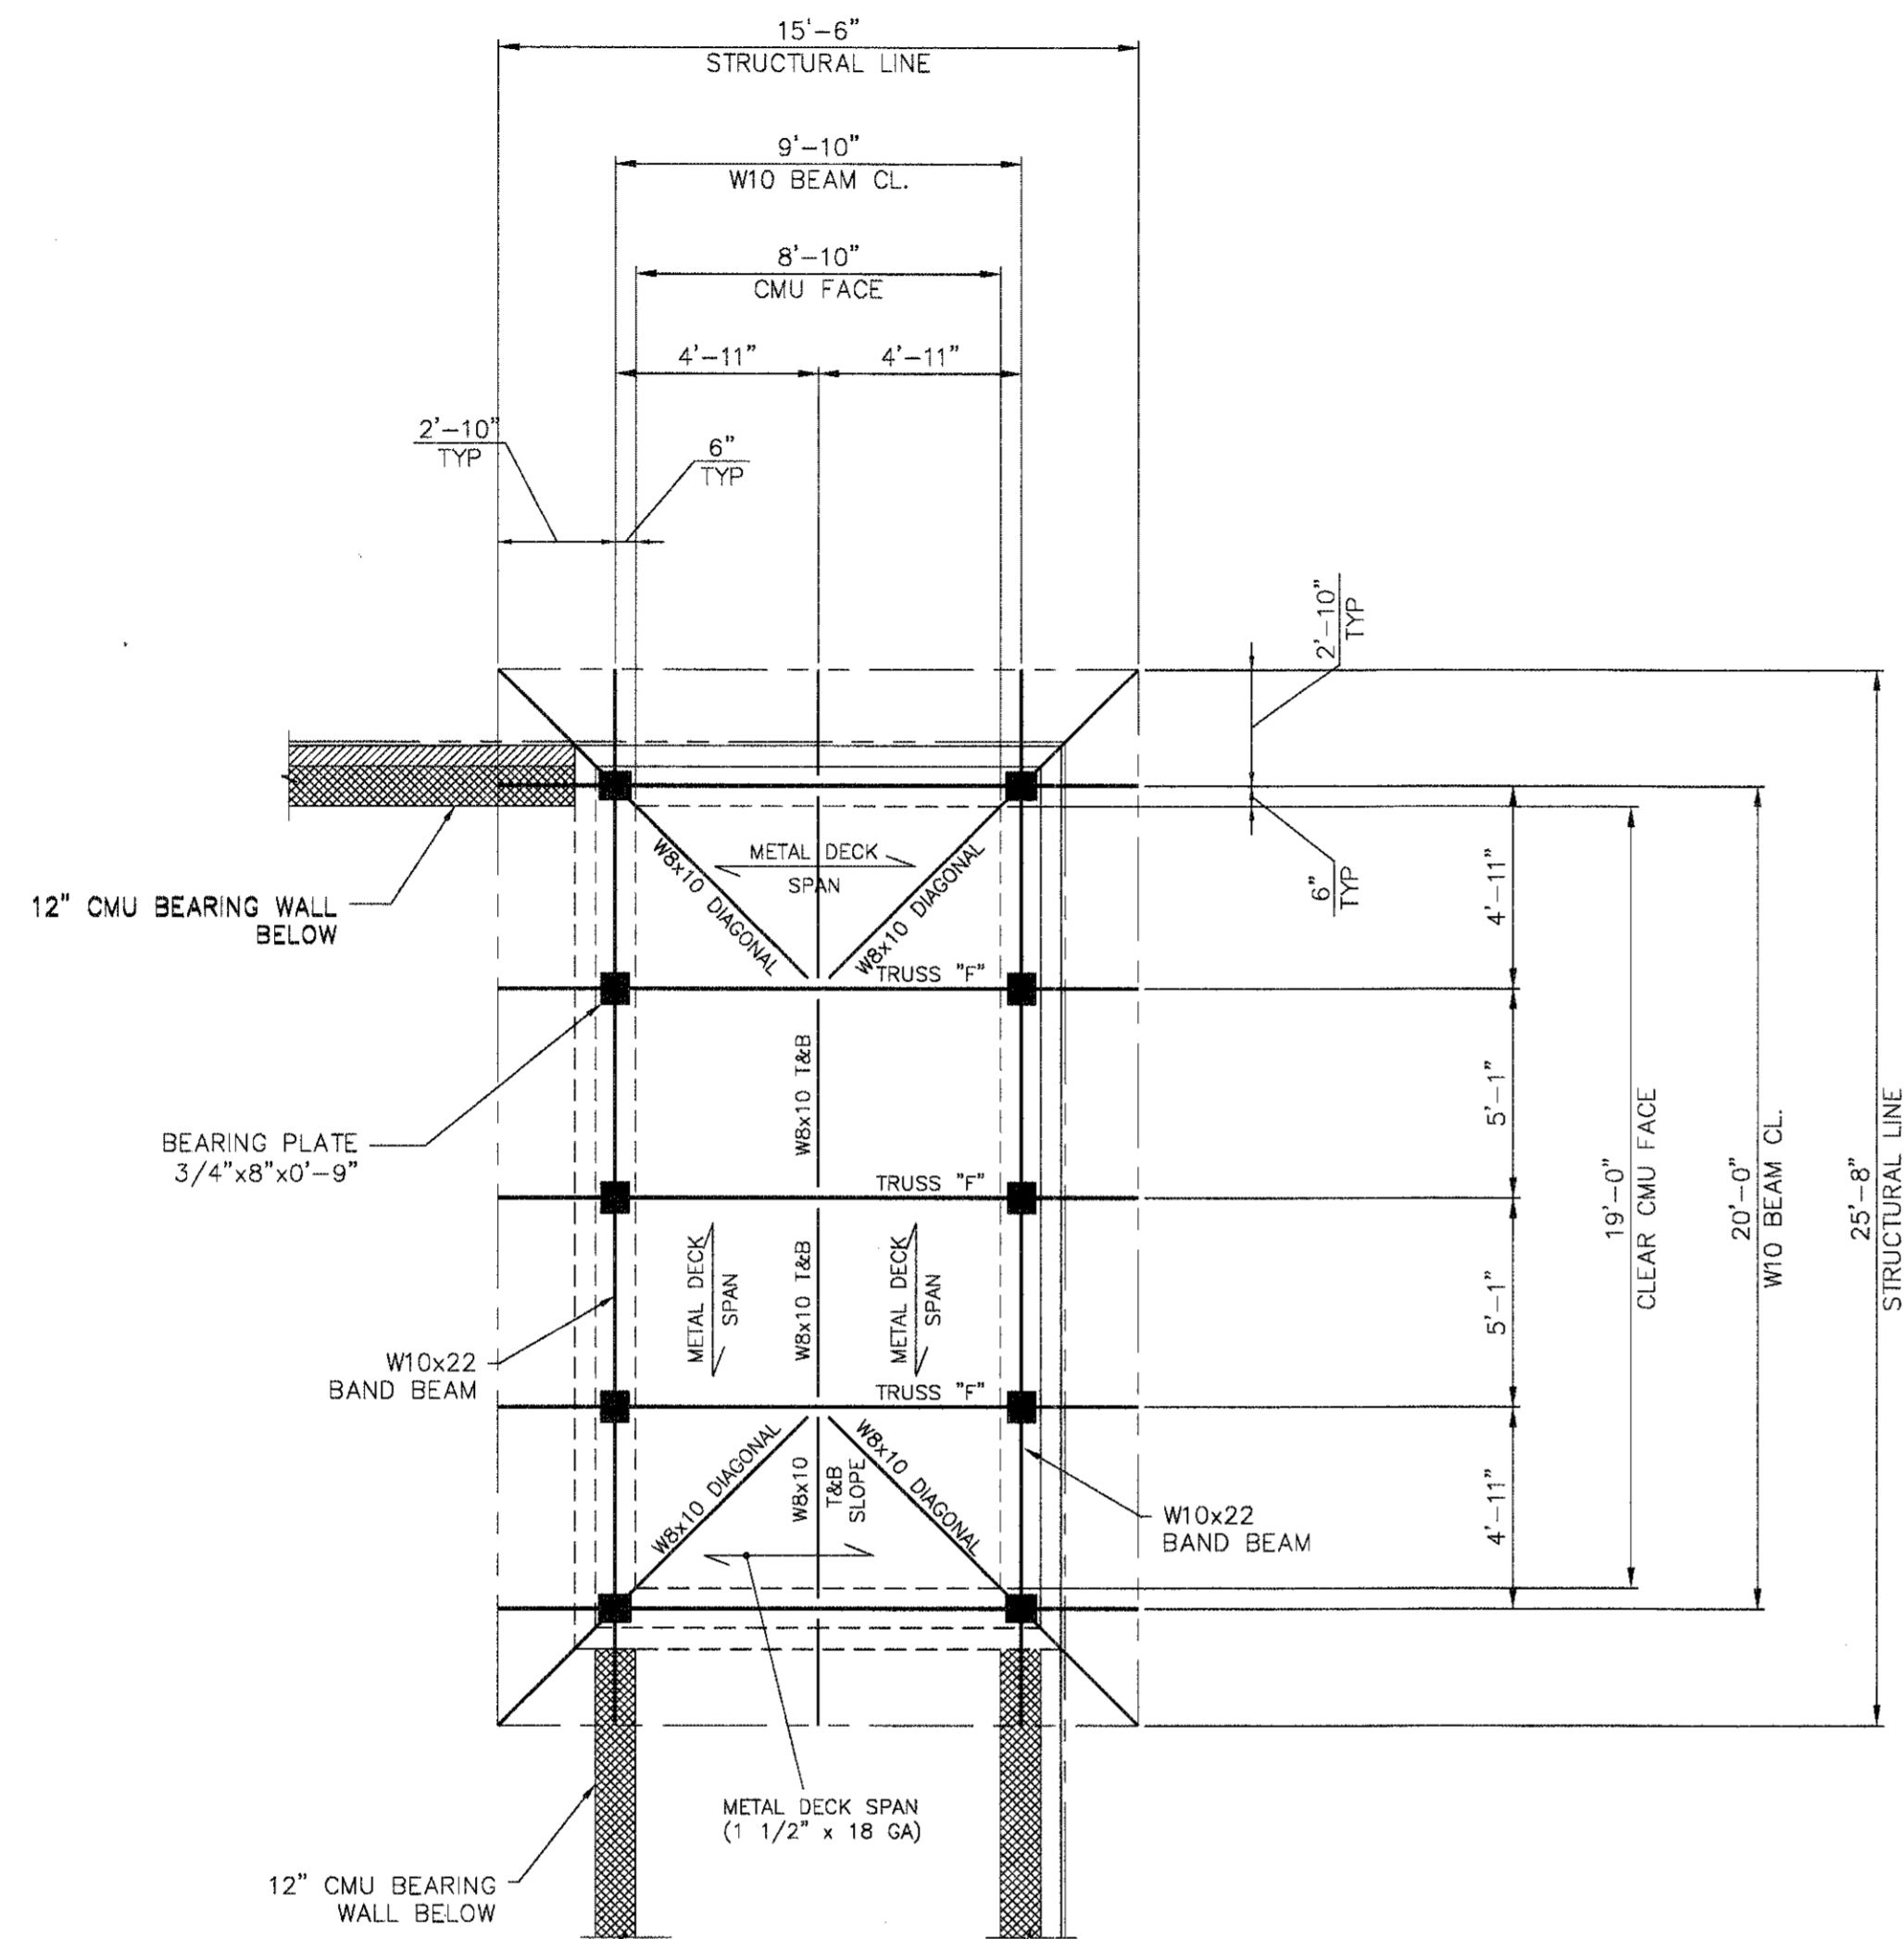



1 PENTHOUSE ROOF FRAME PLAN
S3-105 SCALE: 1/4" = 1'-0"

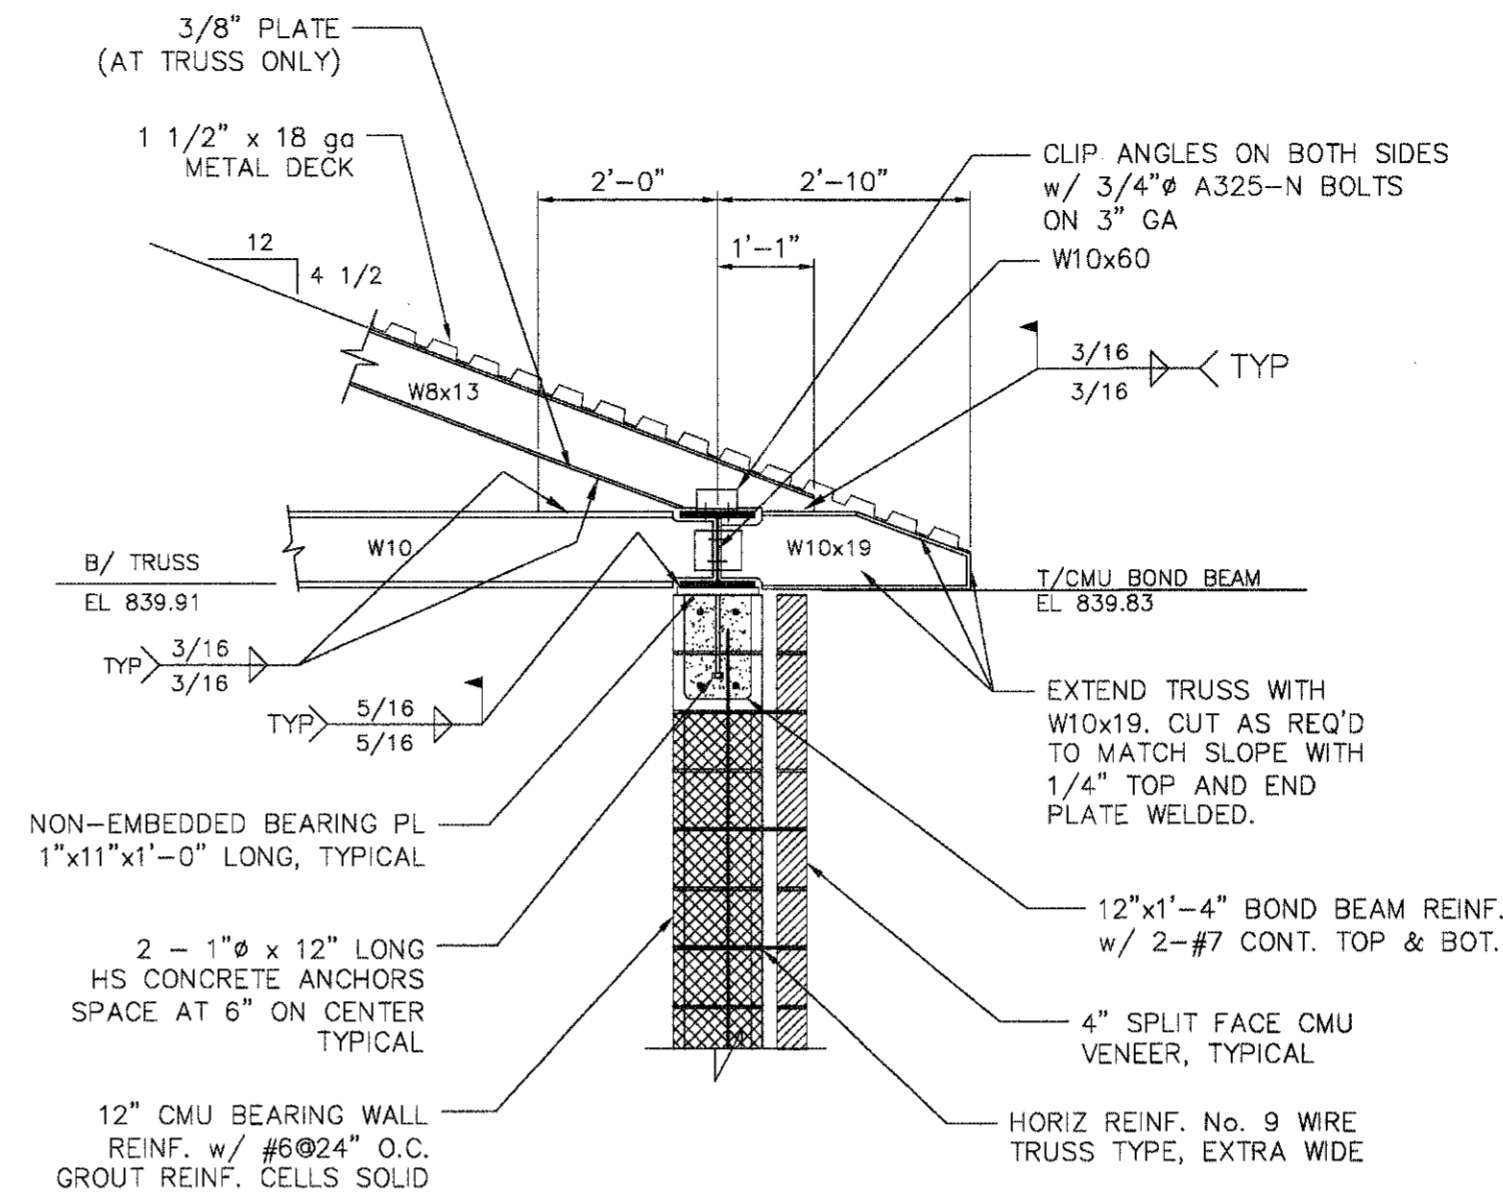

1 DETAIL
S3-105 SCALE: NOT TO SCALE

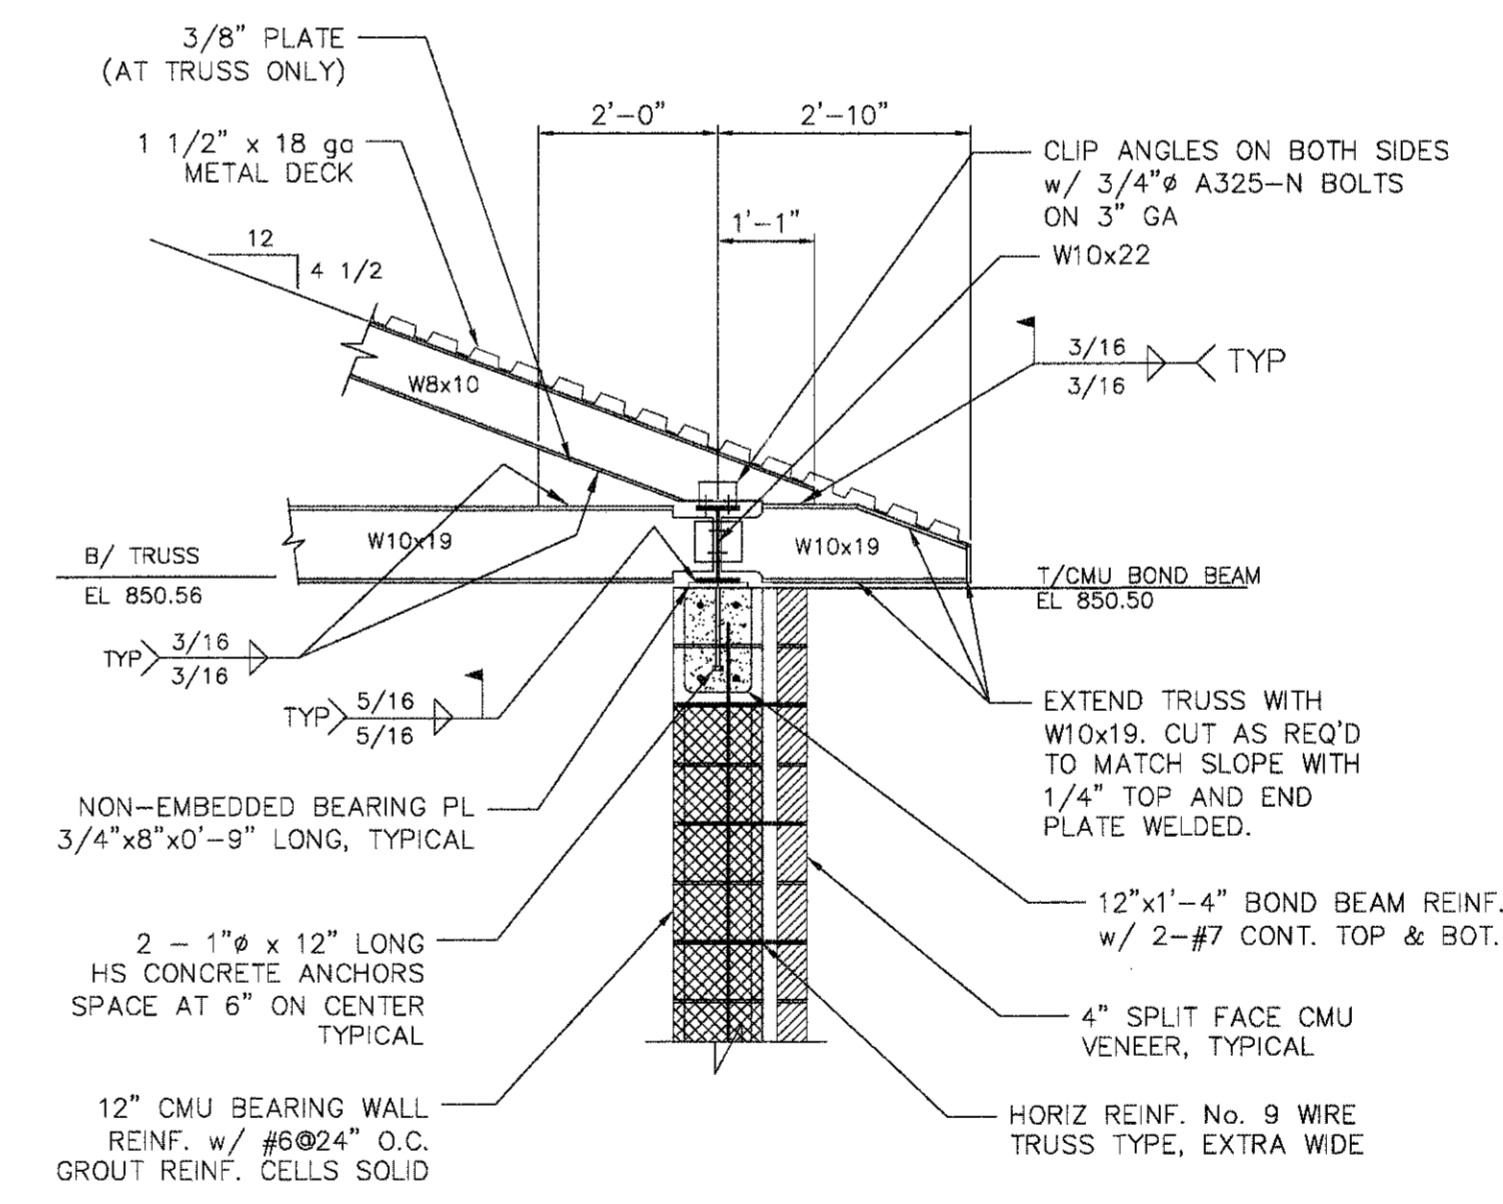

2 DETAIL
S3-105 SCALE: NOT TO SCALE

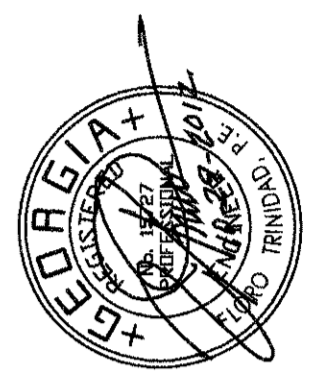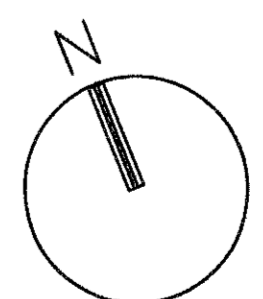

PEACHTREE CREEK SOUTH FORK RELIEF STORAGE AND PUMPING STATION
CITY OF ATLANTA
DEPARTMENT of WATERSHED MANAGEMENT

REV	DATE	DESCRIPTION
0	10/25/12	100 PERCENT BID PACKAGE

THIS LINE IS ONE INCH LONG WHEN PLOTTED FULL SCALE
THIS DRAWING MUST BE USED IN CONJUNCTION WITH THE APPLICABLE OR GOVERNING TECHNICAL SPECIFICATIONS AND OTHER CONTRACT DOCUMENTS.
PROJECT NO: FC-6260
DATE: OCTOBER 2012
RESP PROF: FT DESIGNER: FT CHECKER: DSF
SHEET TITLE: STRUCTURAL
03 - DIVERSION PUMPING STATION
PENTHOUSE ROOF
FRAMING PLAN AND DETAILS
SHEET NO. S3-105 REV. 0