

1 2 3 4 5 6 7 8

F


E

D

C


B

A

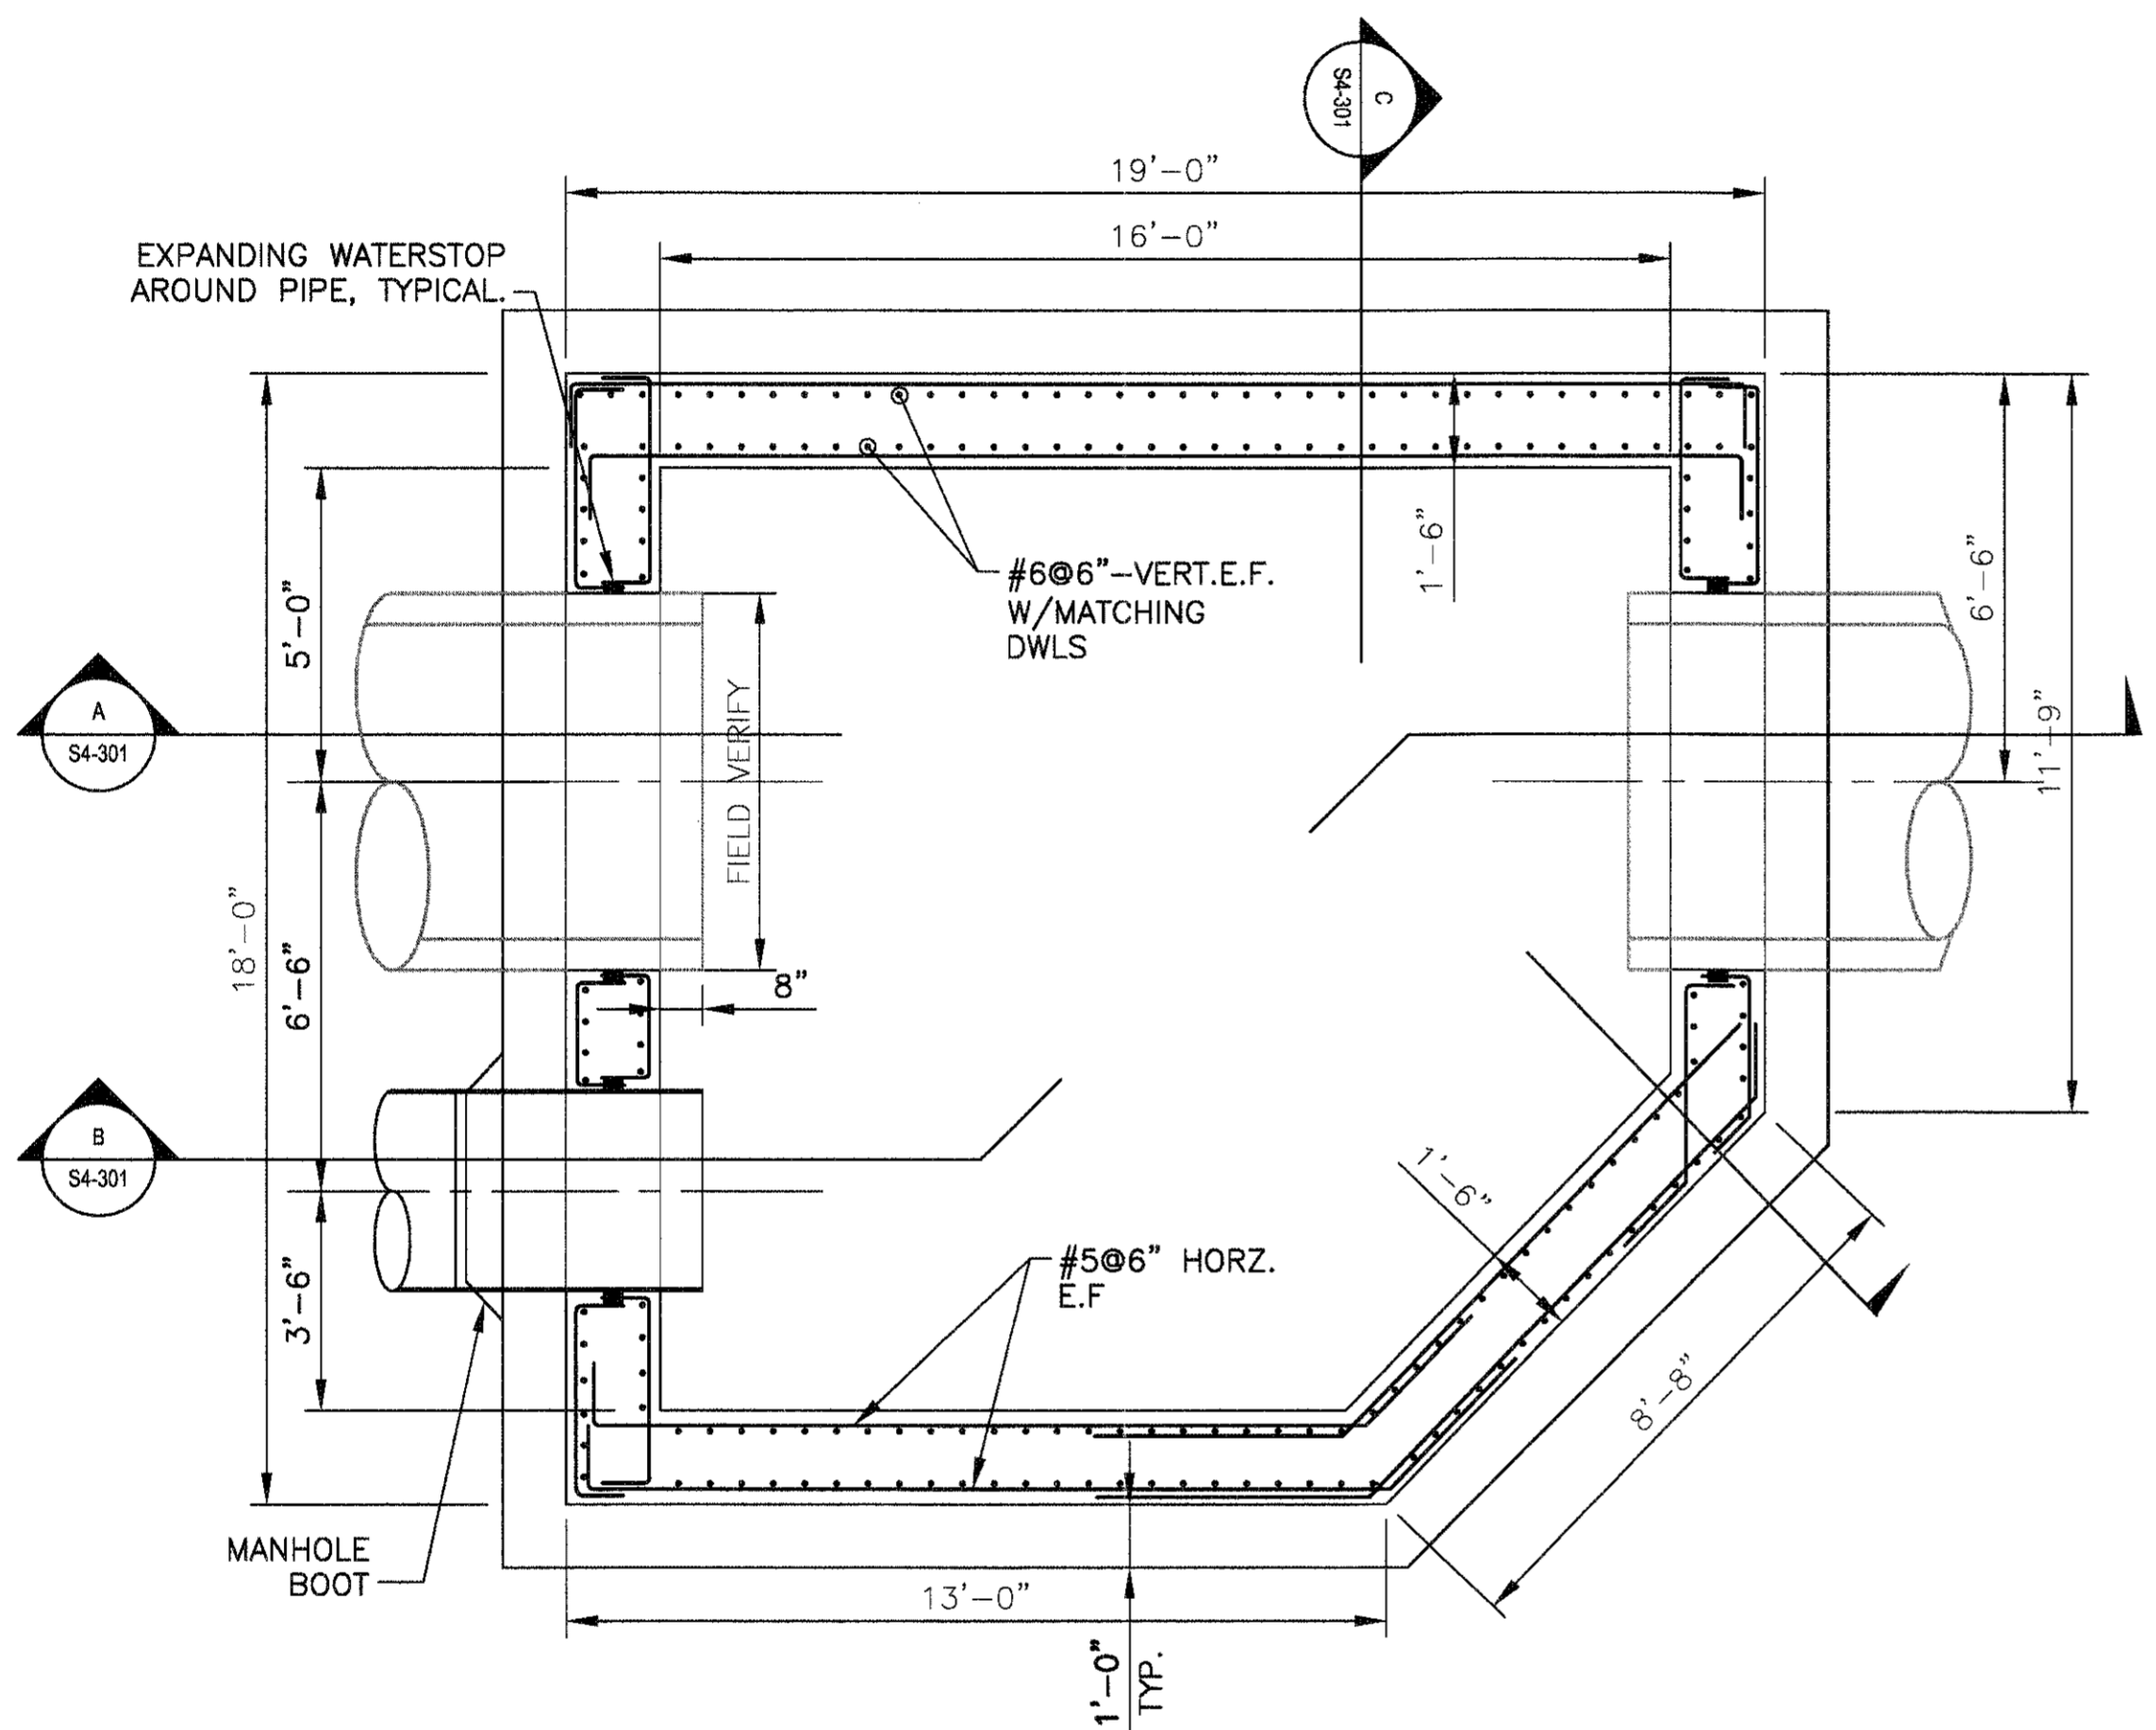


**FOUNDATION PLAN**  
S4-101 SCALE: 3/8" = 1'-0"

NOTE:  
1. SEE CIVIL DRAWINGS TO COORDINATE THE LOCATION OF THE STRUCTURE.  
2. DESIGN LIVE LOAD = 100 PSF.

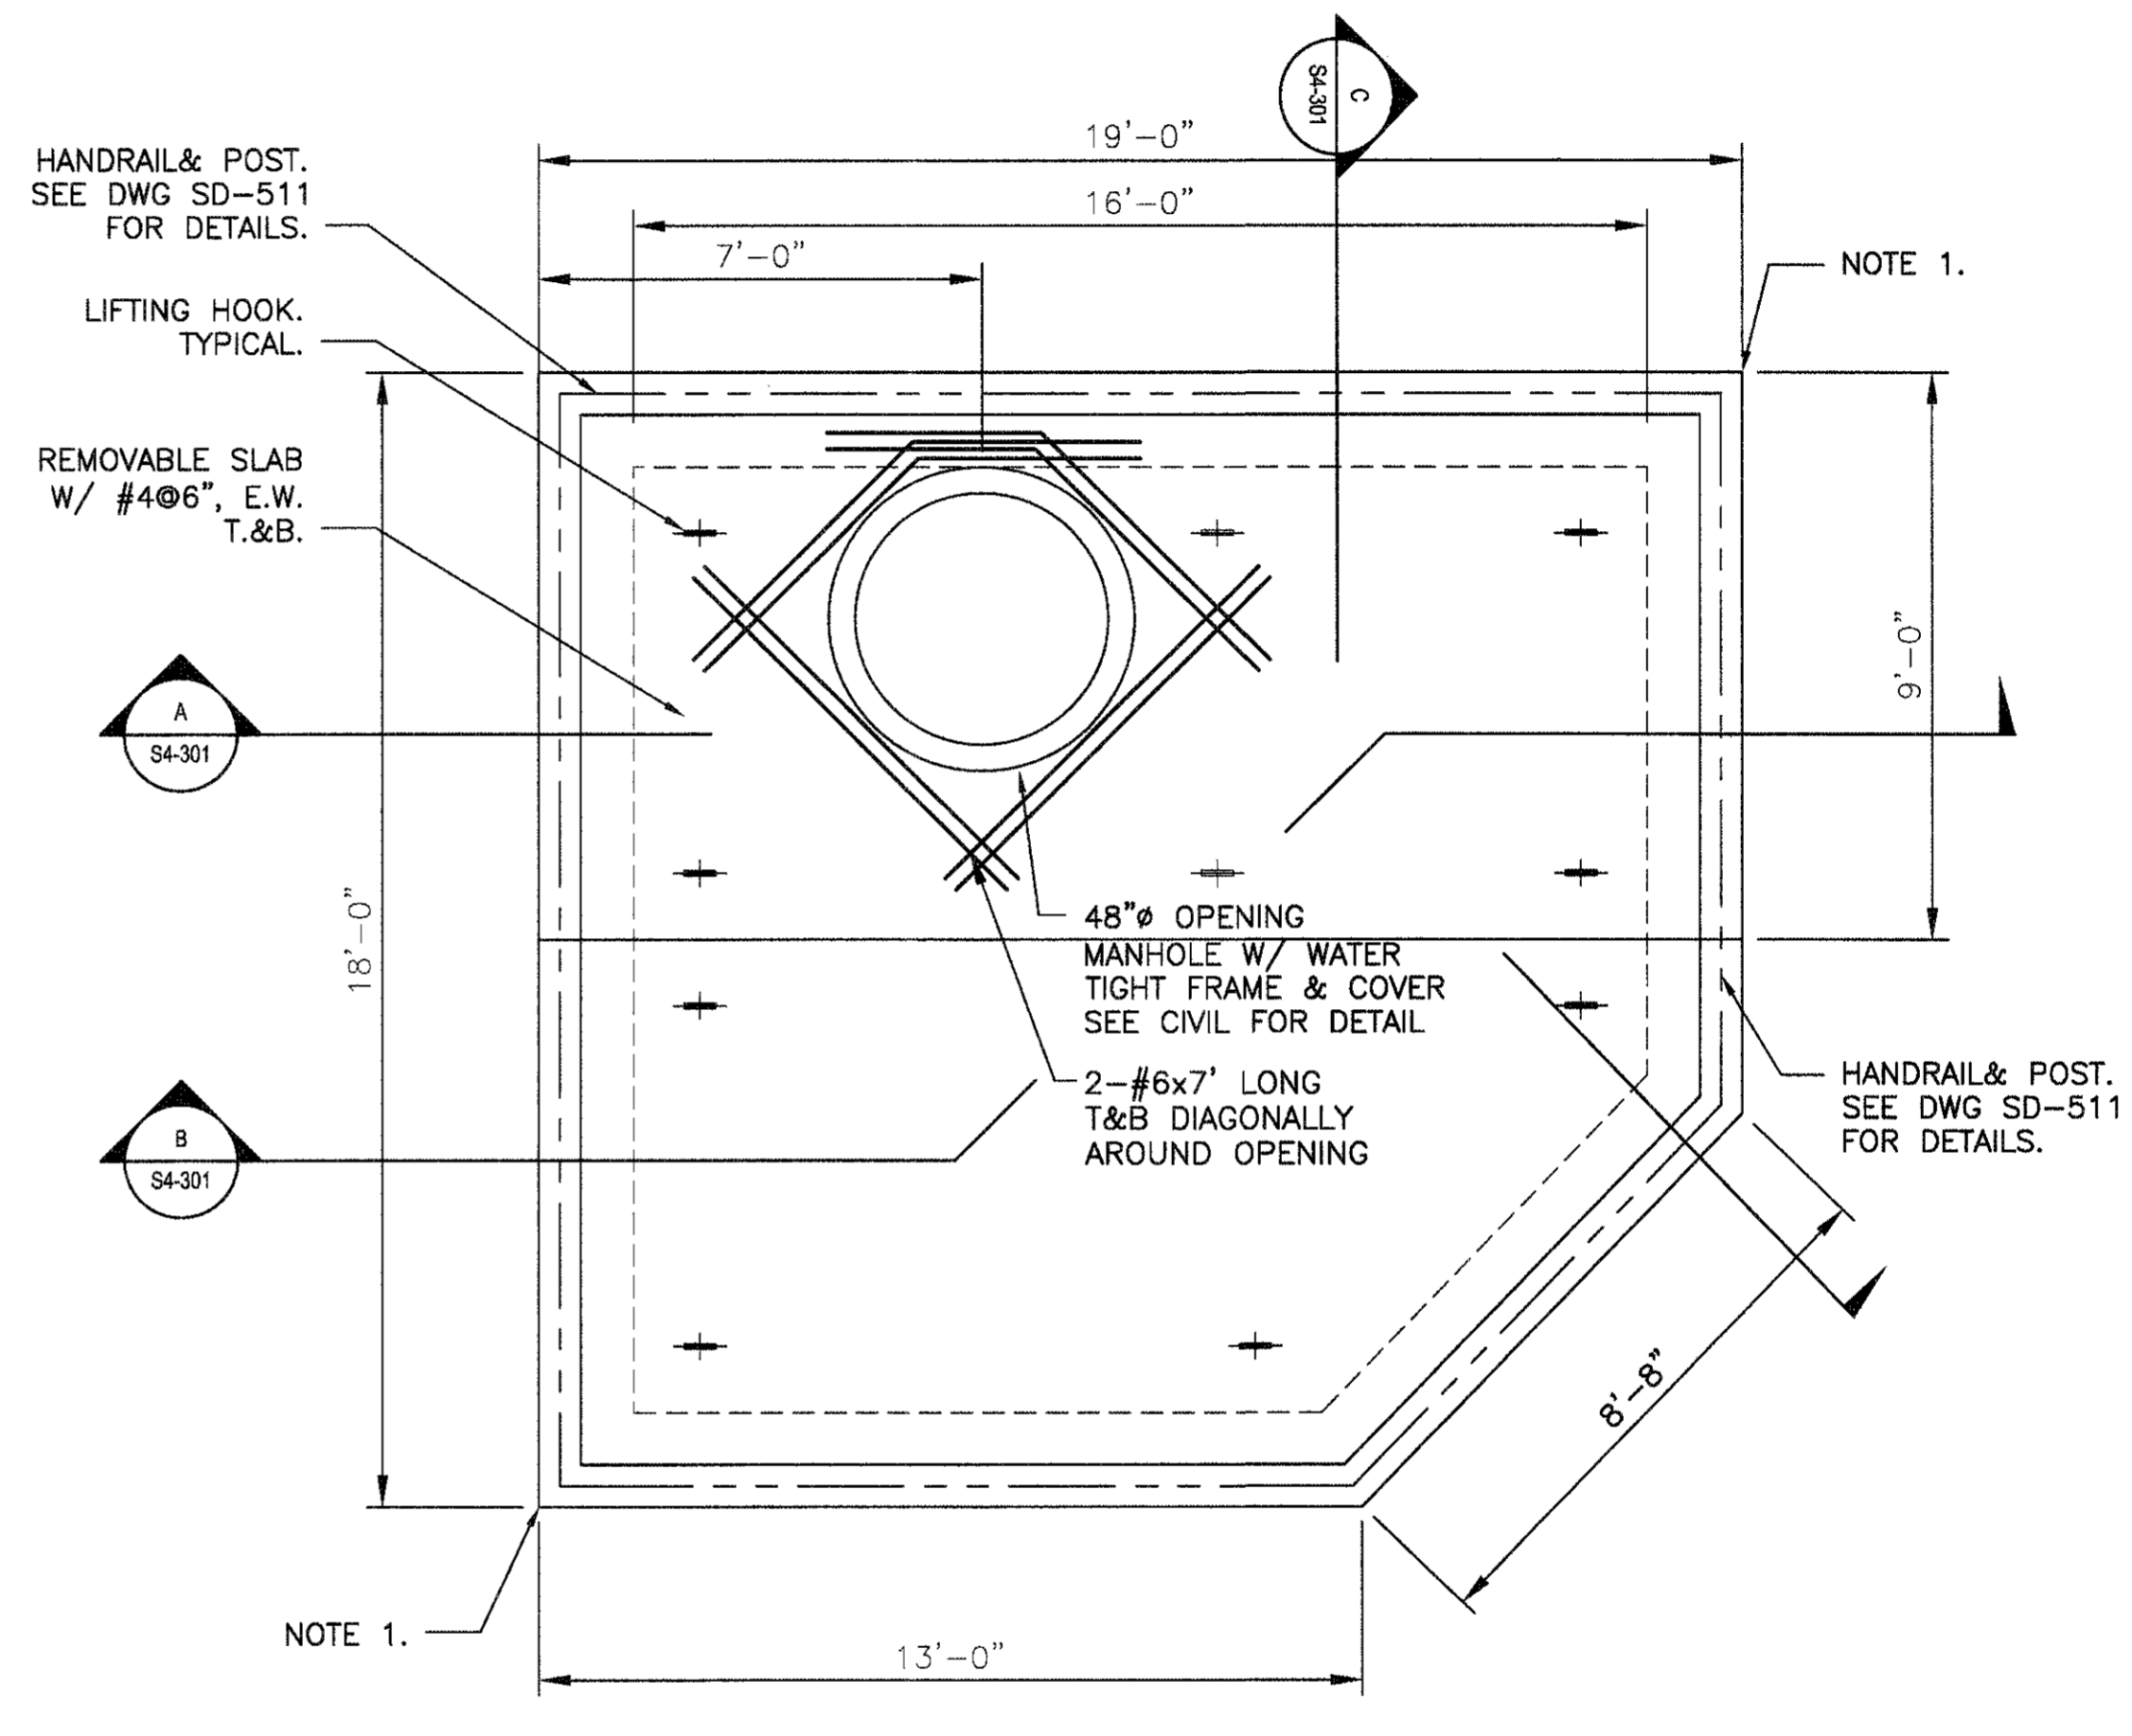

**TOP PLAN**  
S4-101 SCALE: 3/8" = 1'-0"

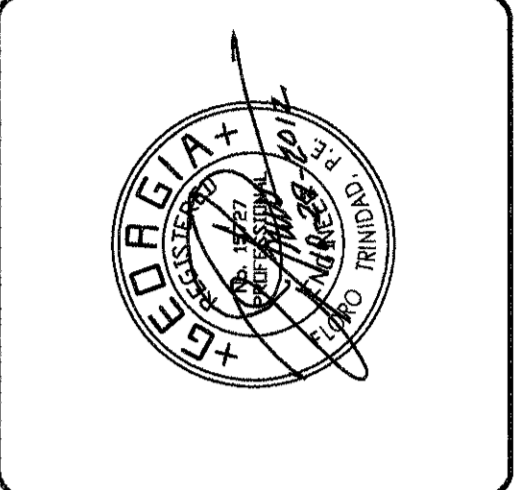

PEACHTREE CREEK SOUTH FORK  
RELIEF STORAGE AND PUMPING STATION  
CITY OF ATLANTA  
DEPARTMENT OF WATERSHED MANAGEMENT

REV	DATE	REVISION DESCRIPTION
0	10/28/12	100 PERCENT BID PACKAGE

THIS LINE IS ONE INCH LONG WHEN PLOTTED FULL SCALE  
THIS DRAWING MUST BE USED IN CONJUNCTION WITH THE APPLICABLE OR GOVERNING TECHNICAL SPECIFICATIONS AND OTHER CONTRACT DOCUMENTS.

PROJECT NO: FC-6260  
DATE: OCTOBER 2012  
RESP PROF: FT DESIGNER: NSH CHECKER: DSF

SHEET TITLE  
STRUCTURAL  
04 - FLOW RETURN STRUCTURE  
PLAN

SHEET NO. S4-101 REV. 0

