

1 2 3 4 5 6 7 8

F



E

D


C

B


A

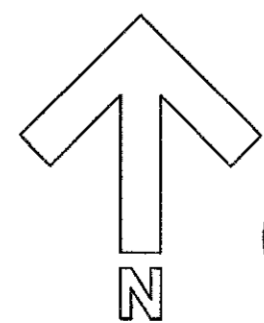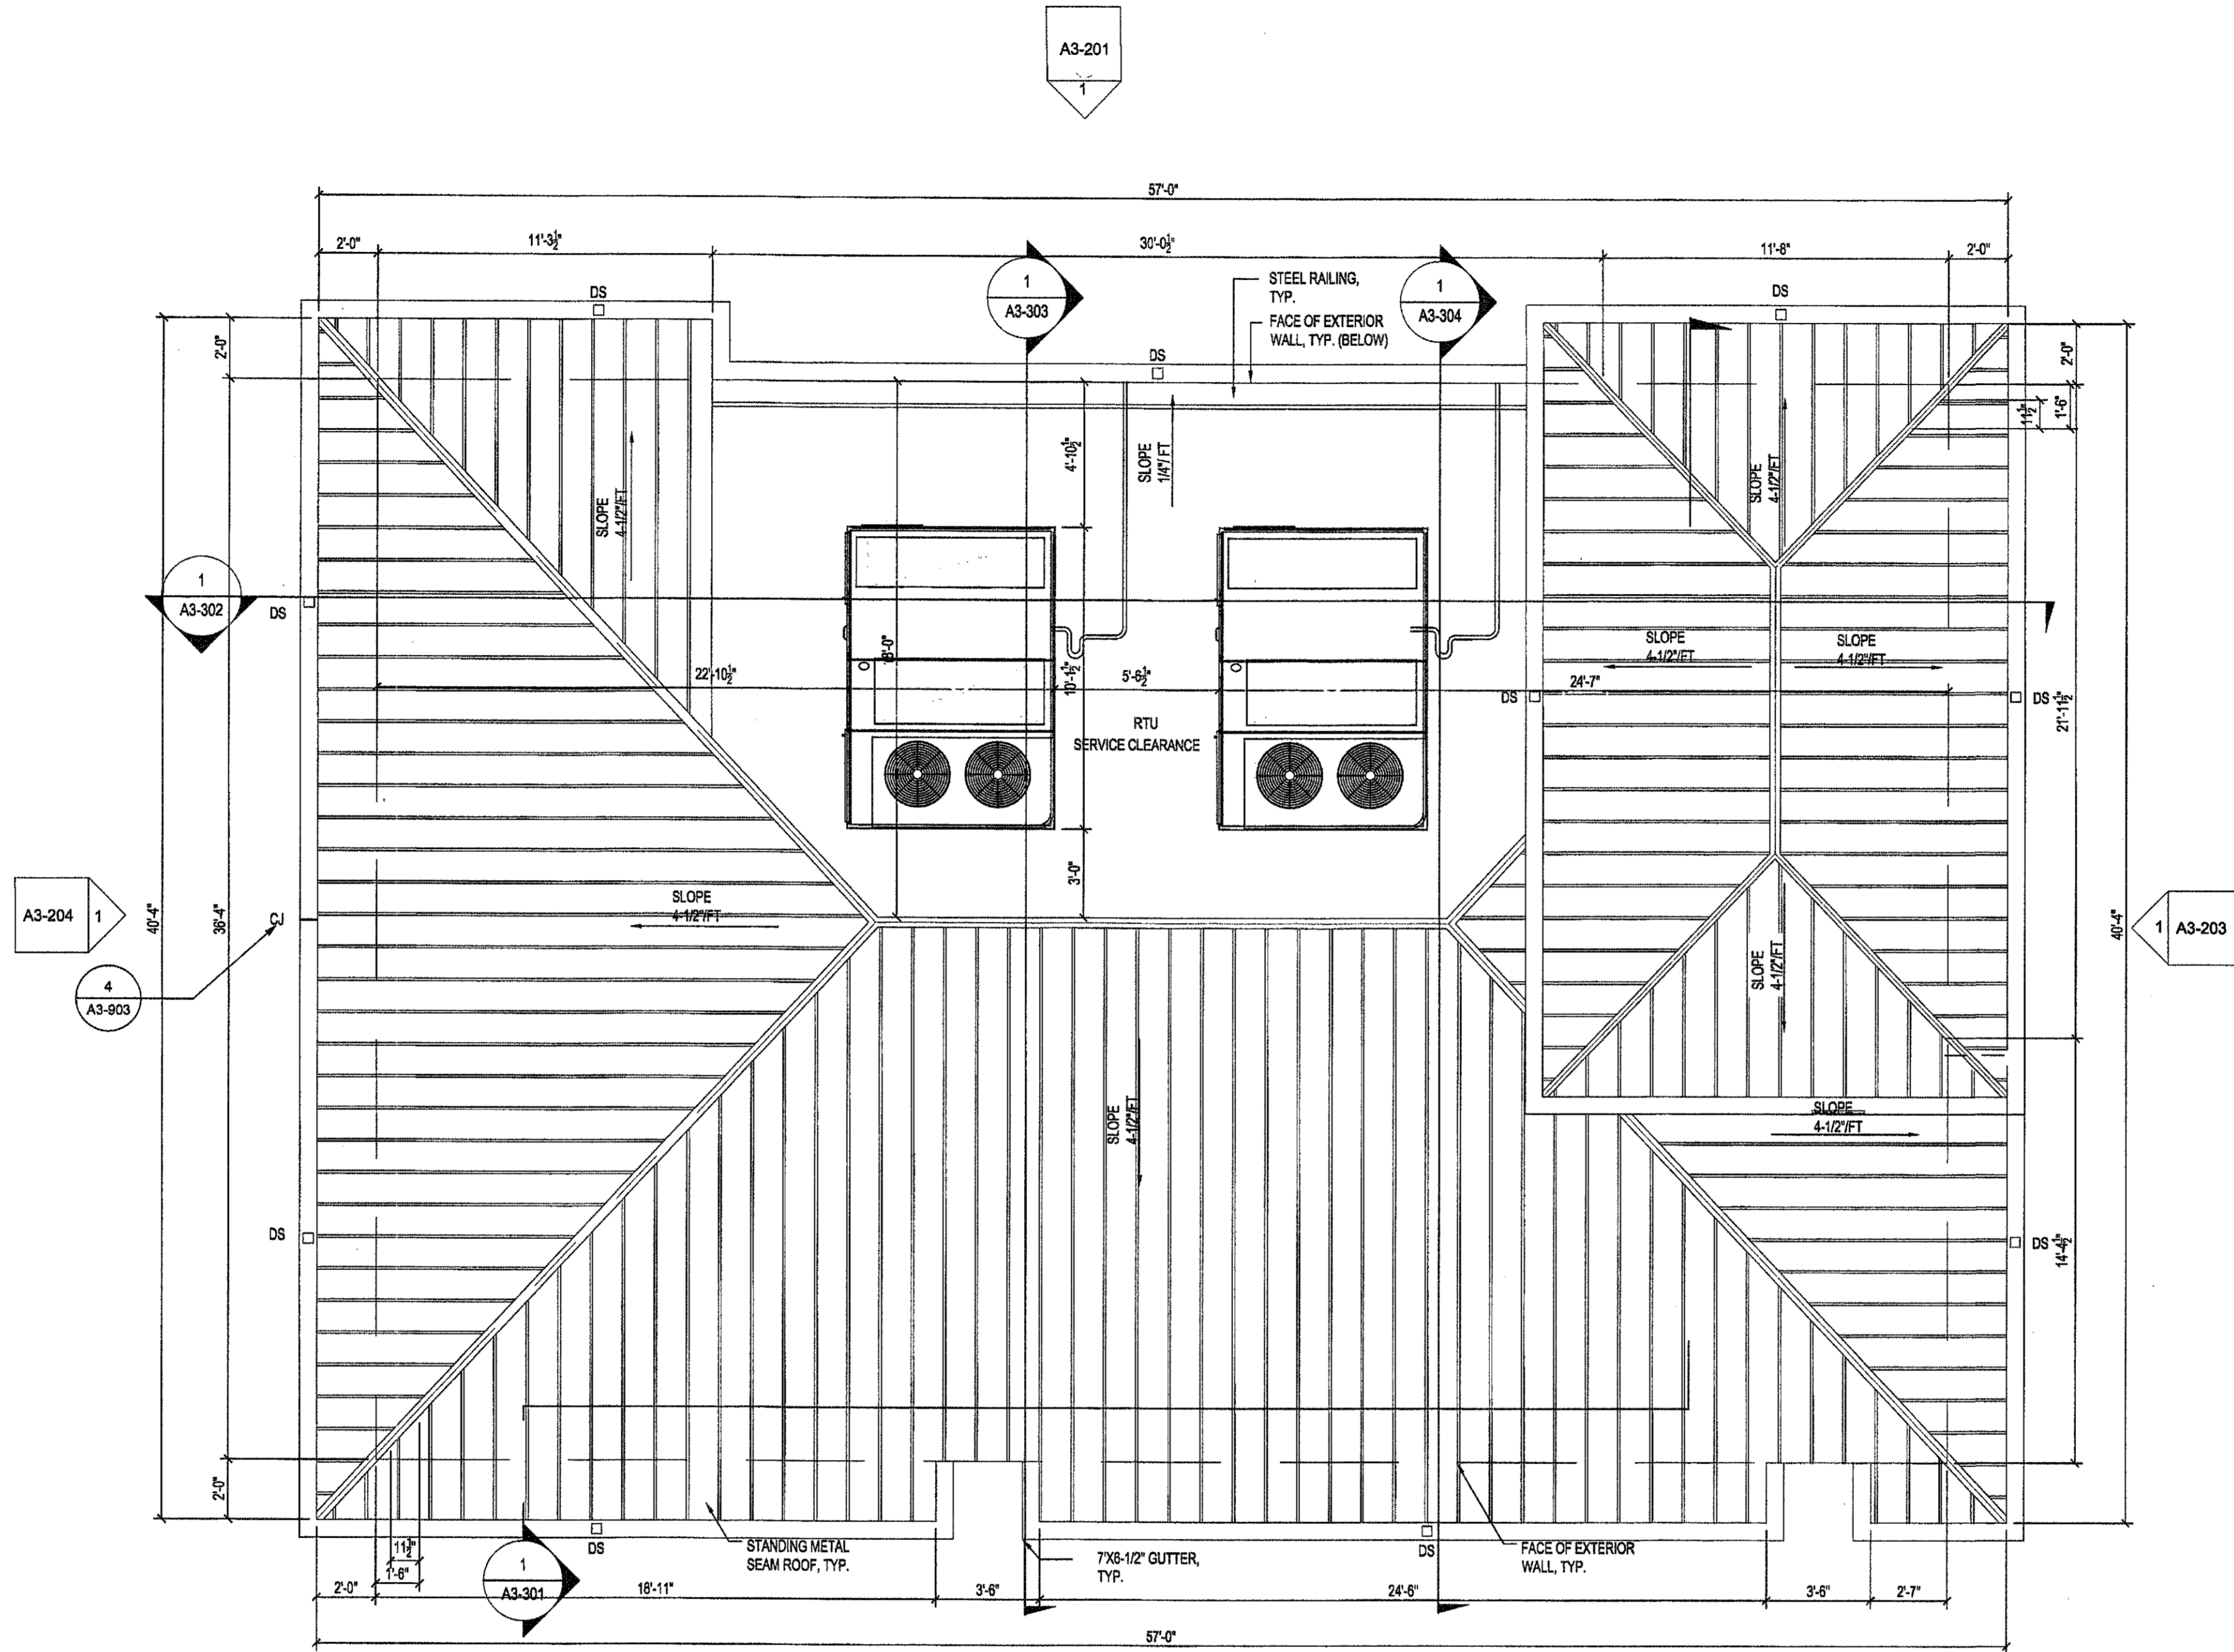

1  
A3-105  
**ROOF PLAN**  
SCALE: 1/4" = 1'-0"

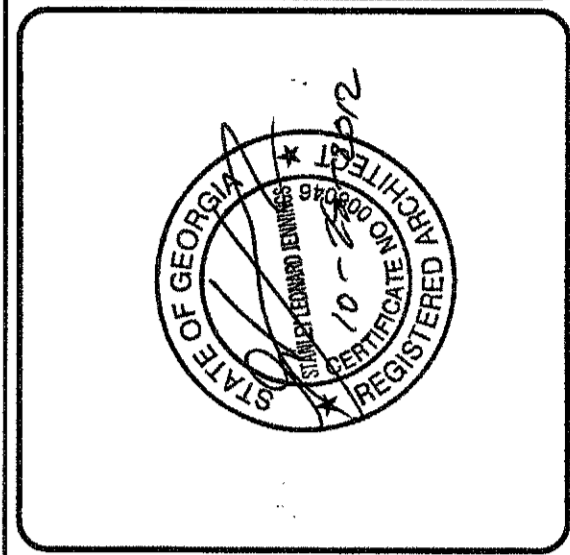

PEACHTREE CREEK SOUTH FORK  
RELIEF STORAGE AND PUMPING STATION



CITY OF ATLANTA  
DEPARTMENT OF WATERSHED MANAGEMENT

REV	DATE	REVISION DESCRIPTION

THIS LINE IS ONE INCH LONG WHEN PLOTTED FULL SCALE.  
THIS DRAWING MUST BE USED IN CONJUNCTION WITH THE APPLICABLE OR GOVERNING TECHNICAL SPECIFICATIONS AND OTHER CONTRACT DOCUMENTS.

PROJECT NO: FC-6260  
DATE: OCTOBER 2012  
RESP PROF: SJ    DESIGNER: CDB    CHECKER: JWR

SHEET TITLE  
ARCHITECTURAL  
03 - DIVERSION FACILITY PUMP STATION  
ROOF PLAN

SHEET NO. A3-105    REV. 0

**J.W. ROBINSON & ASSOCIATES**  
ARCHITECTS • INTERIOR DESIGNERS • URBAN PLANNERS  
1020 RALPH DAVID ABERNATHY BLVD., S.W., ATLANTA, GEORGIA 30310  
PHONE: (404) 763-4129 FAX: (404) 763-4435