

1 2 3 4 5 6 7 8

F


E

D

C



B

A

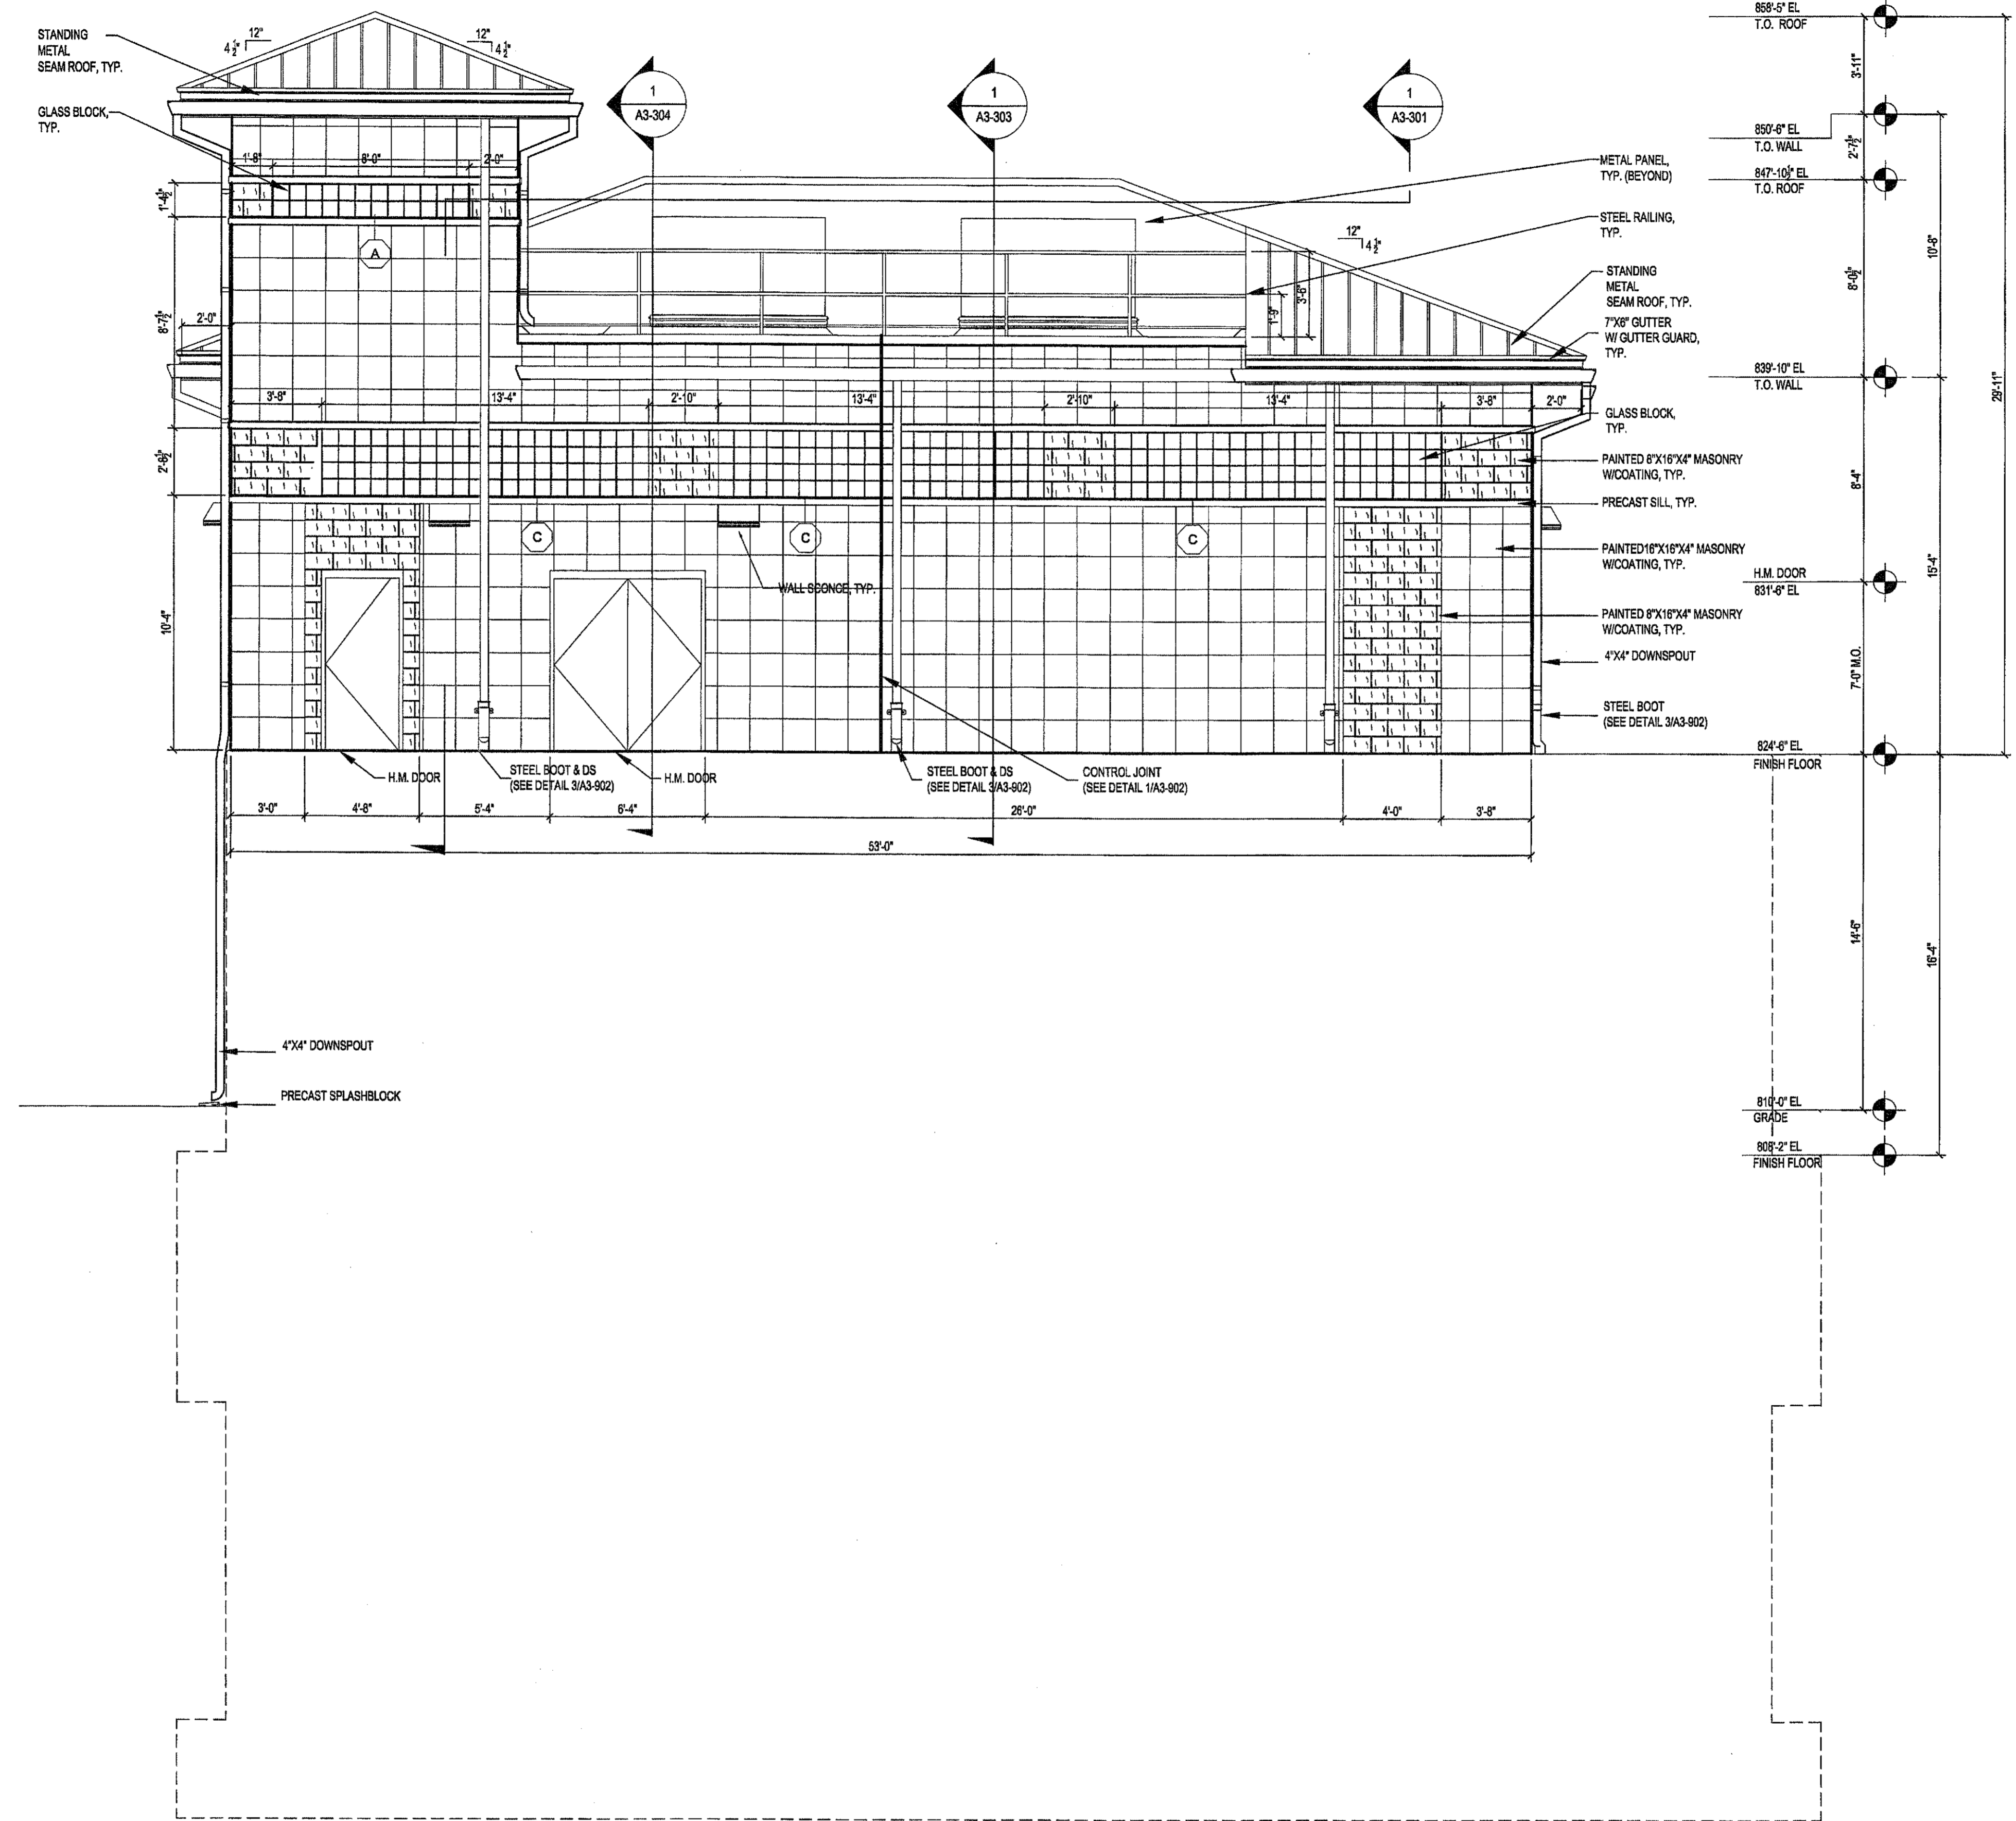


1 NORTH ELEVATION
A3-201 SCALE: 1/4" = 1'-0"

J. W. ROBINSON & ASSOCIATES
ARCHITECTS • INTERIOR DESIGNERS • URBAN PLANNERS
1020 RALPH DAVID ABERNATHY BLVD., S.W., ATLANTA, GEORGIA 30310
PHONE: (404) 753-4129 FAX: (404) 753-4436

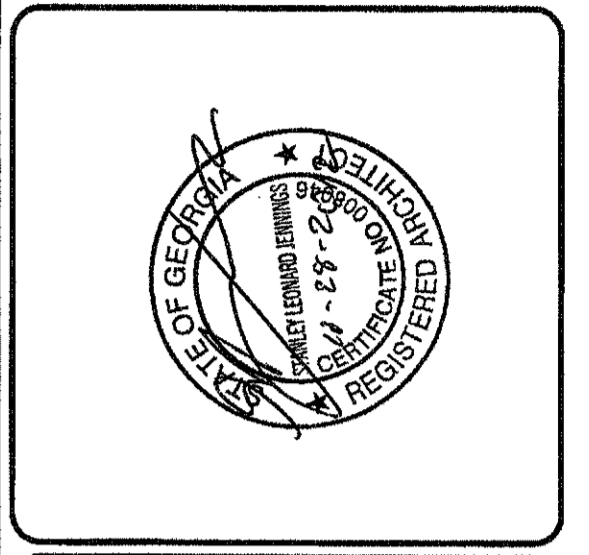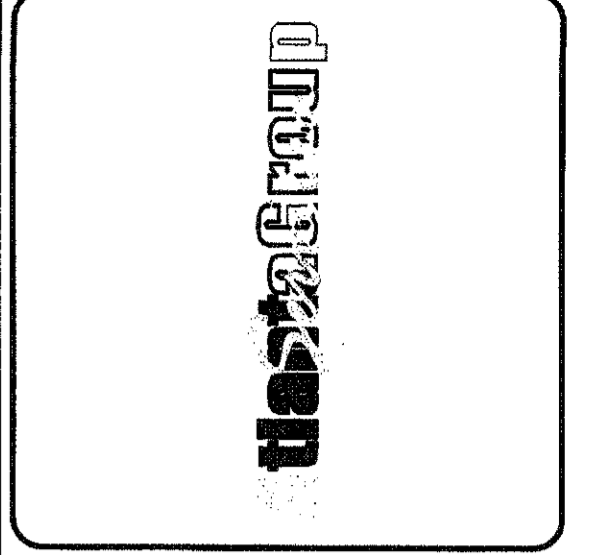

PEACHTREE CREEK SOUTH FORK
RELIEF STORAGE AND PUMPING STATION



CITY OF ATLANTA
DEPARTMENT of WATERSHED MANAGEMENT

REV	DATE	REVISION DESCRIPTION

THIS LINE IS ONE INCH LONG WHEN PLOTTED FULL SCALE
THIS DRAWING MUST BE USED IN CONJUNCTION WITH THE APPLICABLE OR GOVERNING TECHNICAL SPECIFICATIONS AND OTHER CONTRACT DOCUMENTS.

PROJECT NO: FC-6260
DATE: OCTOBER 2012
RESP PROF: SJ DESIGNER: CDB CHECKER: JWR

SHEET TITLE
ARCHITECTURAL
03 - DIVERSION FACILITY PUMP STATION
ELEVATIONS

SHEET NO. A3-201 REV. 0