

1 2 3 4 5 6 7 8

F


E

D


C

B

A

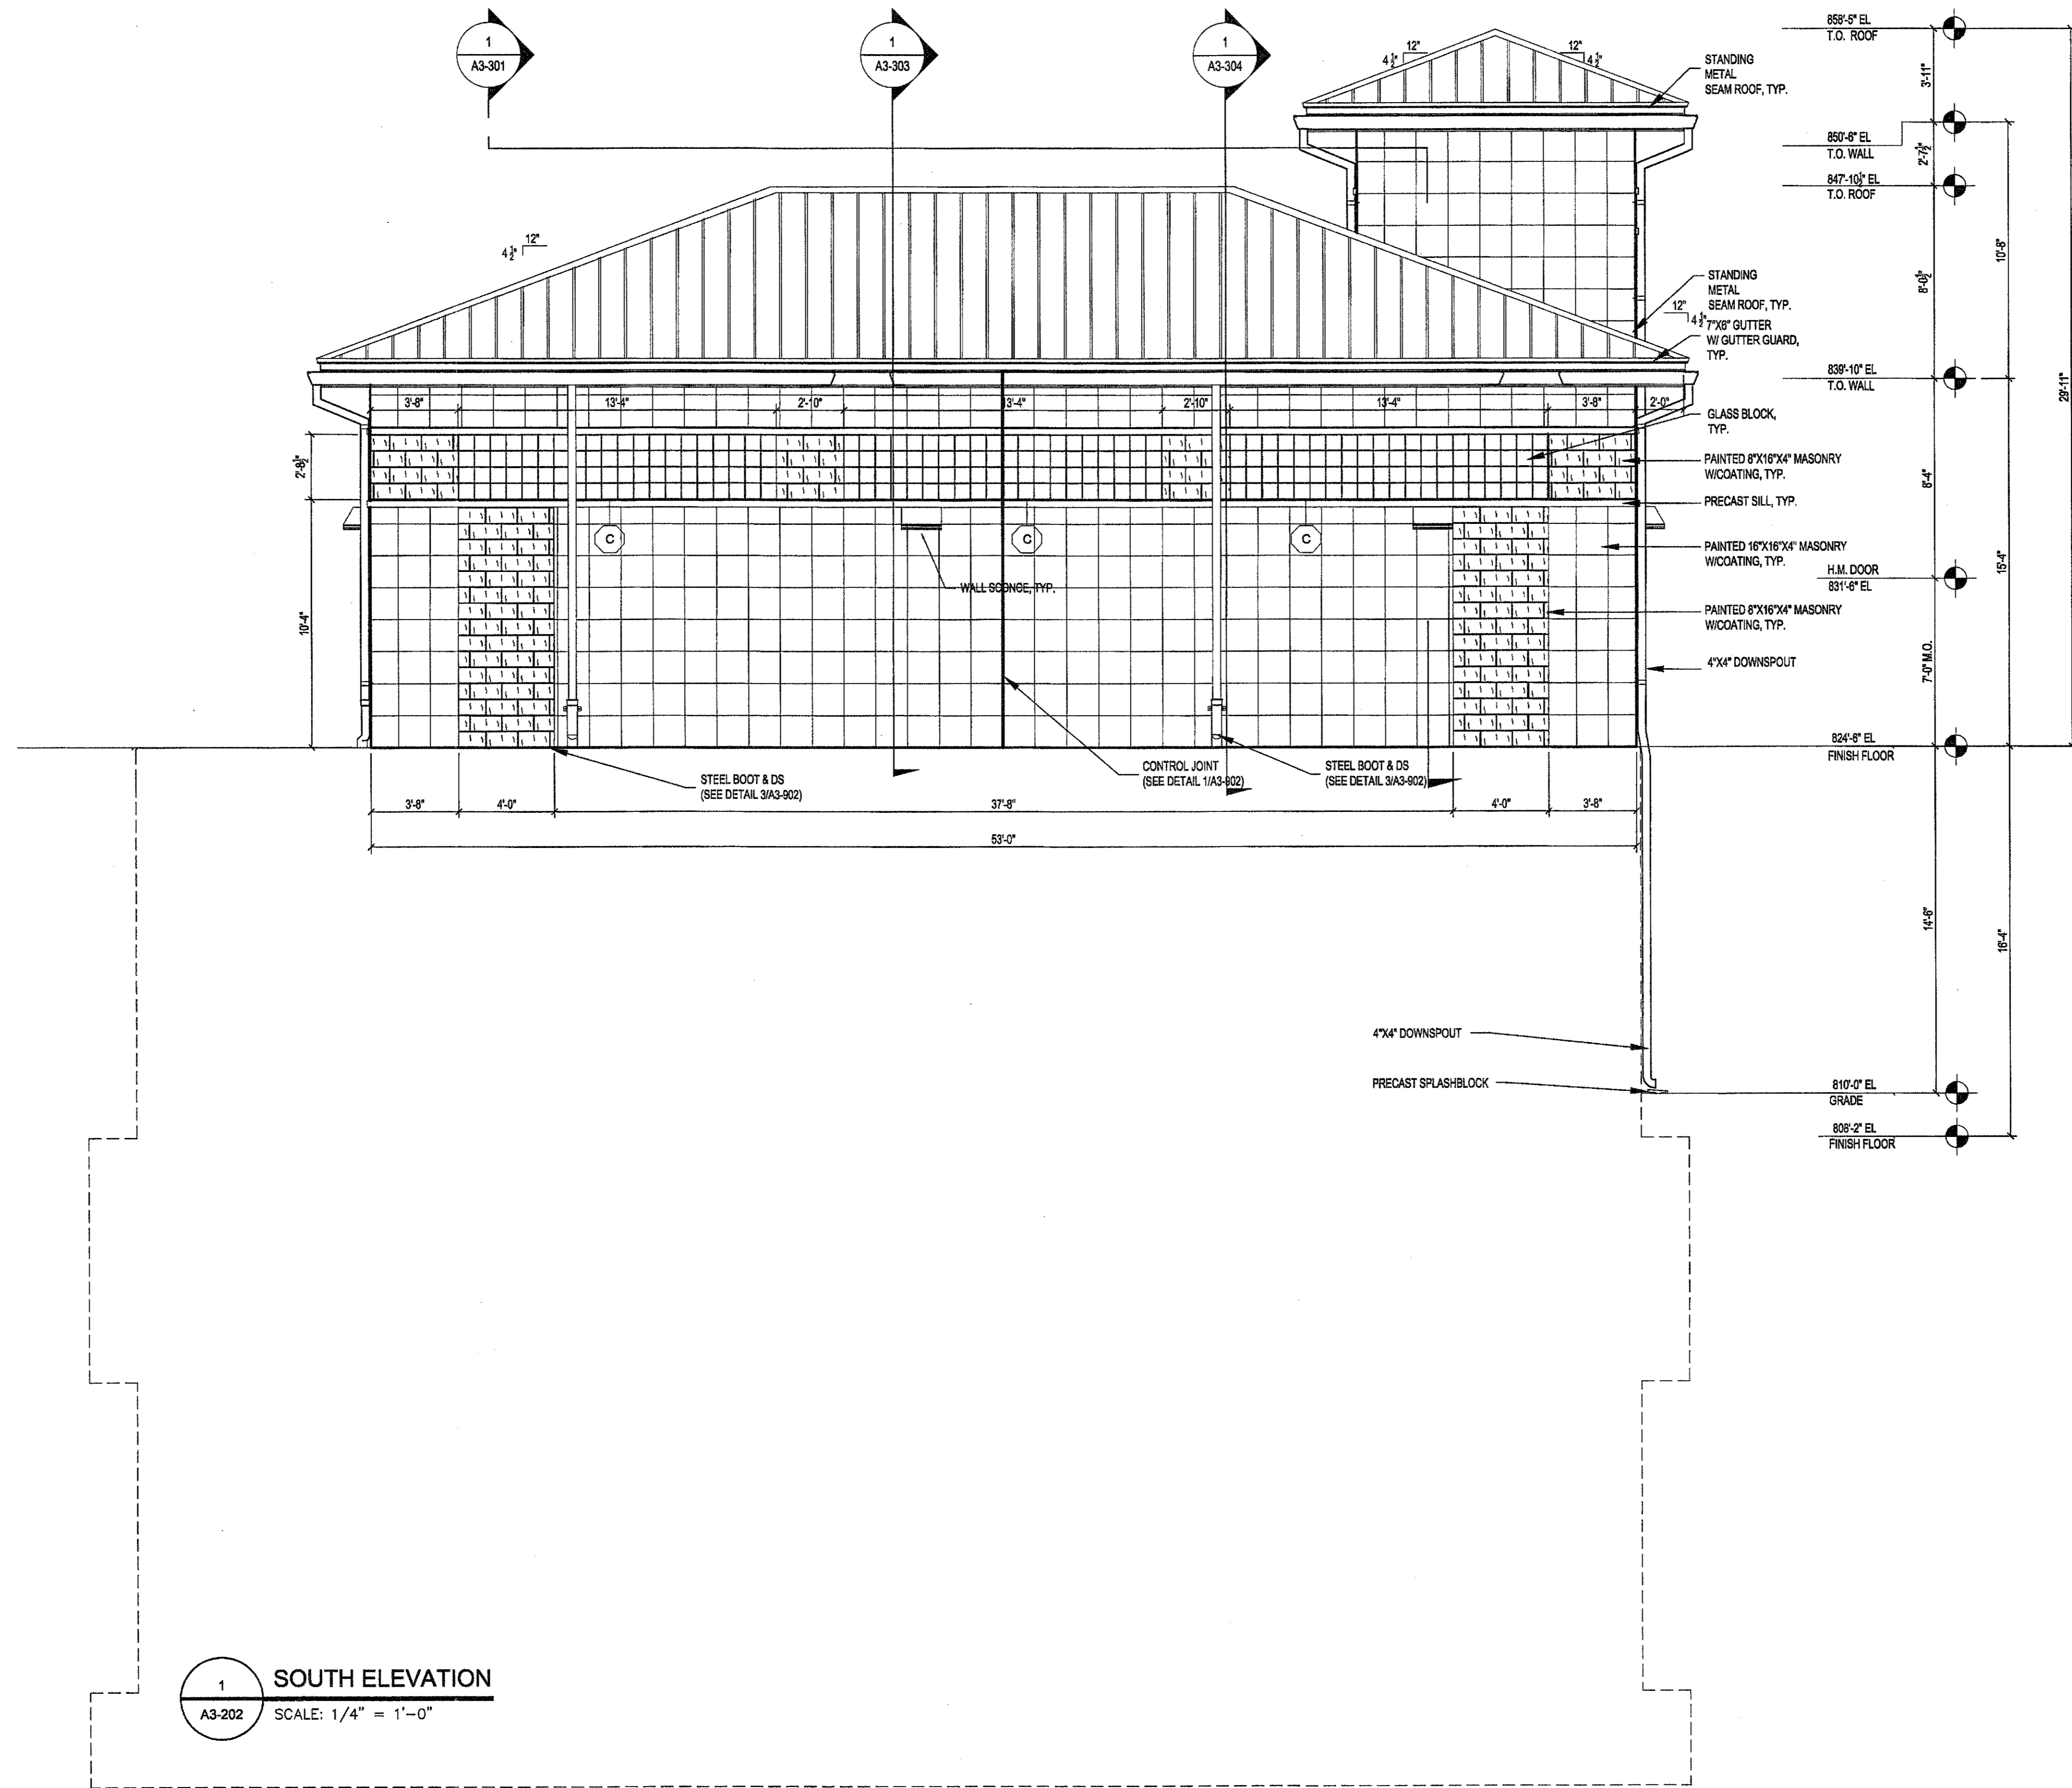

1 SOUTH ELEVATION  
A3-202 SCALE: 1/4" = 1'-0"

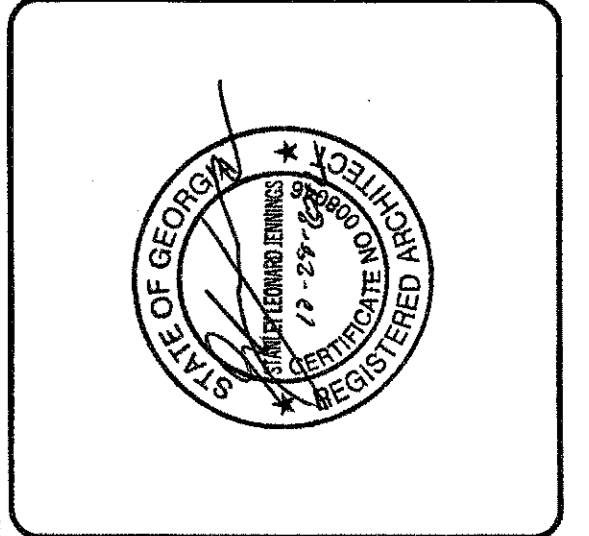

PEACHTREE CREEK SOUTH FORK  
RELIEF STORAGE AND PUMPING STATION  
CITY OF ATLANTA  
DEPARTMENT of WATERSHED MANAGEMENT

REV	DATE	REVISION DESCRIPTION

THIS LINE IS ONE INCH LONG WHEN PLOTTED FULL SCALE

THIS DRAWING MUST BE USED IN CONJUNCTION WITH THE APPLICABLE OR GOVERNING TECHNICAL SPECIFICATIONS AND OTHER CONTRACT DOCUMENTS.

PROJECT NO: FC-6260  
DATE: OCTOBER 2012

RESP PROF: SJ	DESIGNER: CDB	CHECKER: JWR
------------------	------------------	-----------------

SHEET TITLE  
ARCHITECTURAL  
03 - DIVERSION FACILITY PUMP STATION  
ELEVATION

SHEET NO. A3-202	REV. 0
---------------------	-----------

**J. W. ROBINSON & ASSOCIATES**  
ARCHITECTS • INTERIOR DESIGNERS • URBAN PLANNERS  
1020 RALPH DAVID ABERNATHY BLVD., S.W., ATLANTA, GEORGIA 30310  
PHONE: (404) 753-4129 FAX: (404) 753-4435