

F


E

D

C

B

A

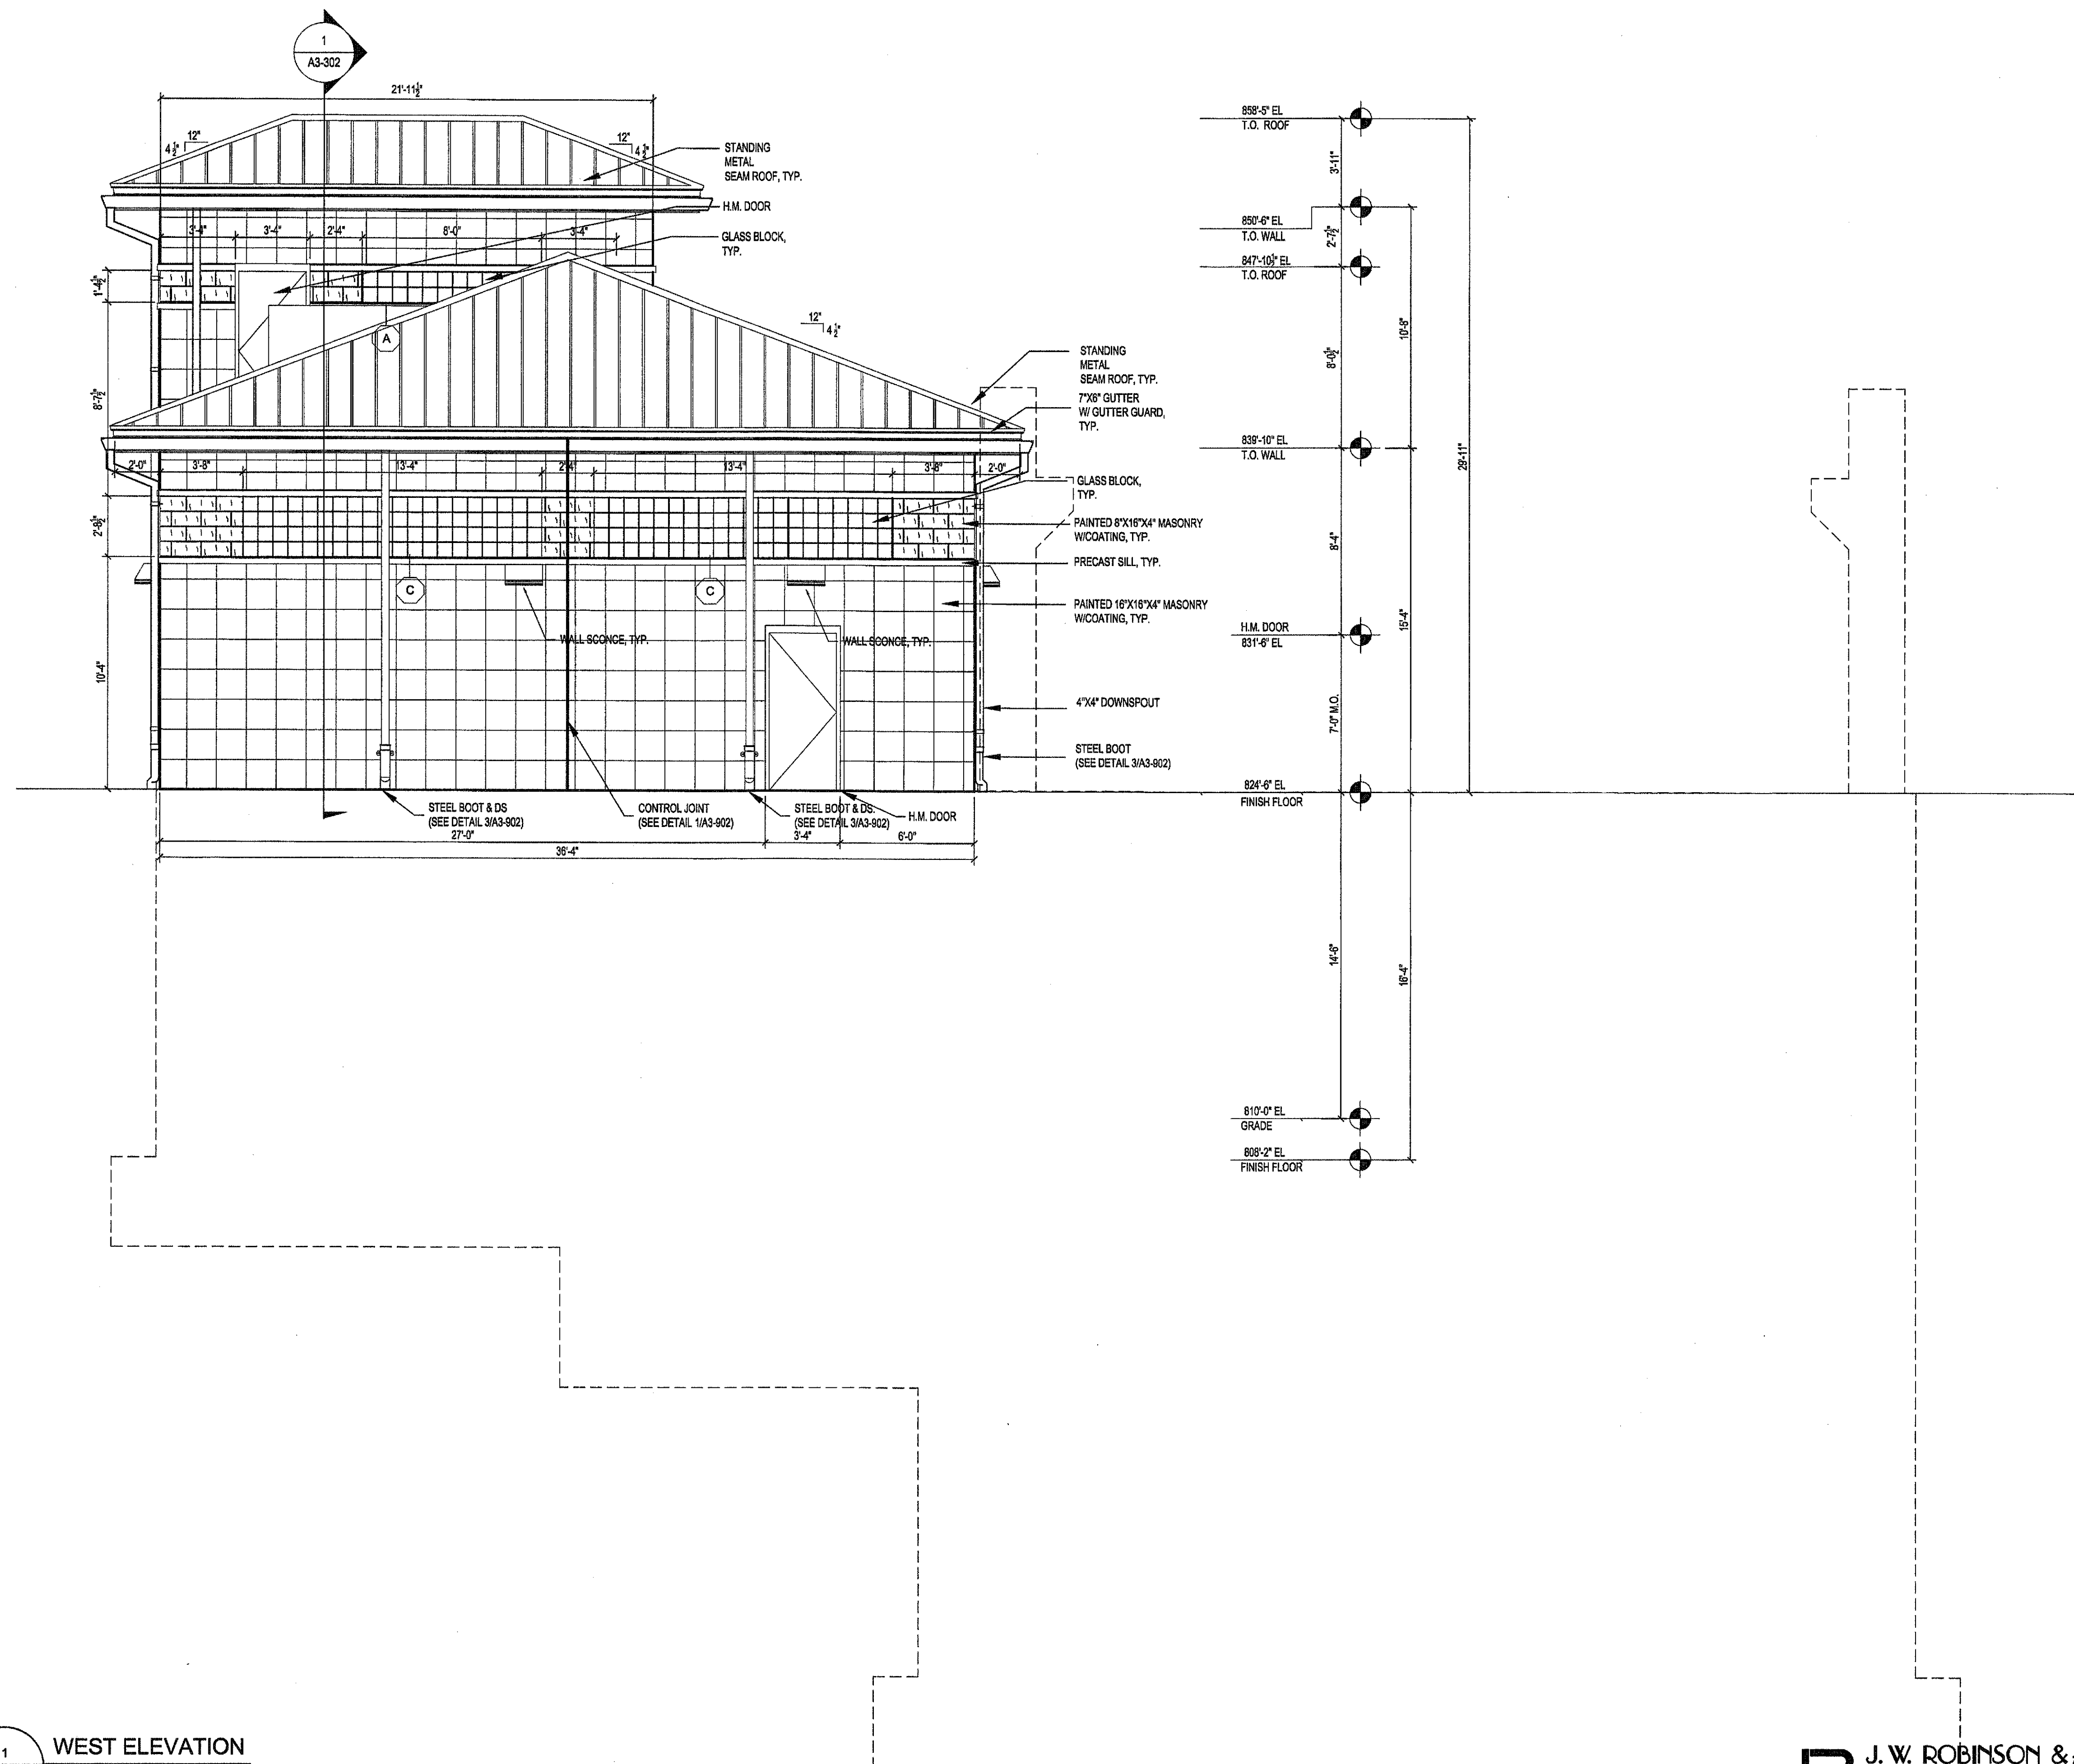

1
A3-204

WEST ELEVATION


SCALE: $1/4" = 1'-0"$



J. W. ROBINSON & ASSOCIATES

• ARCHITECTS • INTERIOR DESIGNERS • URBAN PLANNERS

1020 RALPH DAVID ABERNATHY BLVD., S.W., ATLANTA, GEORGIA 30331
PHONE: (404) 753-4138, FAX: (404) 753-4435

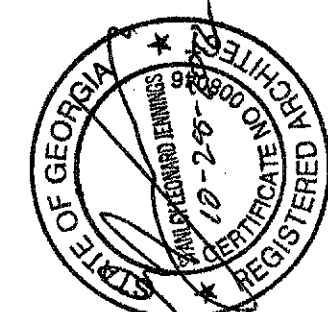PEACHTREE CREEK SOUTH FORK
RELIEF STORAGE AND PUMPING STATION

PEACHTREE CREEK SOUTH FORK
RELIEF STORAGE AND PUMPING STATION



CITY OF ATLANTA
DEPARTMENT of WATERSHED MANAGEMENT

[illegible]

THIS LINE _____ IS ONE INCH
LONG WHEN PLOTTED FULL SCALE

THIS DRAWING MUST BE USED IN CONJUNCTION
WITH THE APPLICABLE OR GOVERNING TECHNICAL
SPECIFICATIONS AND OTHER CONTRACT DOCUMENTS.

PROJECT NO: FC-6260

DATE: OCTOBER 2012

RESP PROF:	DESIGNER:
------------	-----------

SI	CDB
----	-----

30	CDB
CHIEF OF POLICE	

SHEET TITLE

ARCHITECT

03 - DIVERSION I

STAT

ELEVAT