

1 2 3 4 5 6 7 8

F


E

D

C

B

A

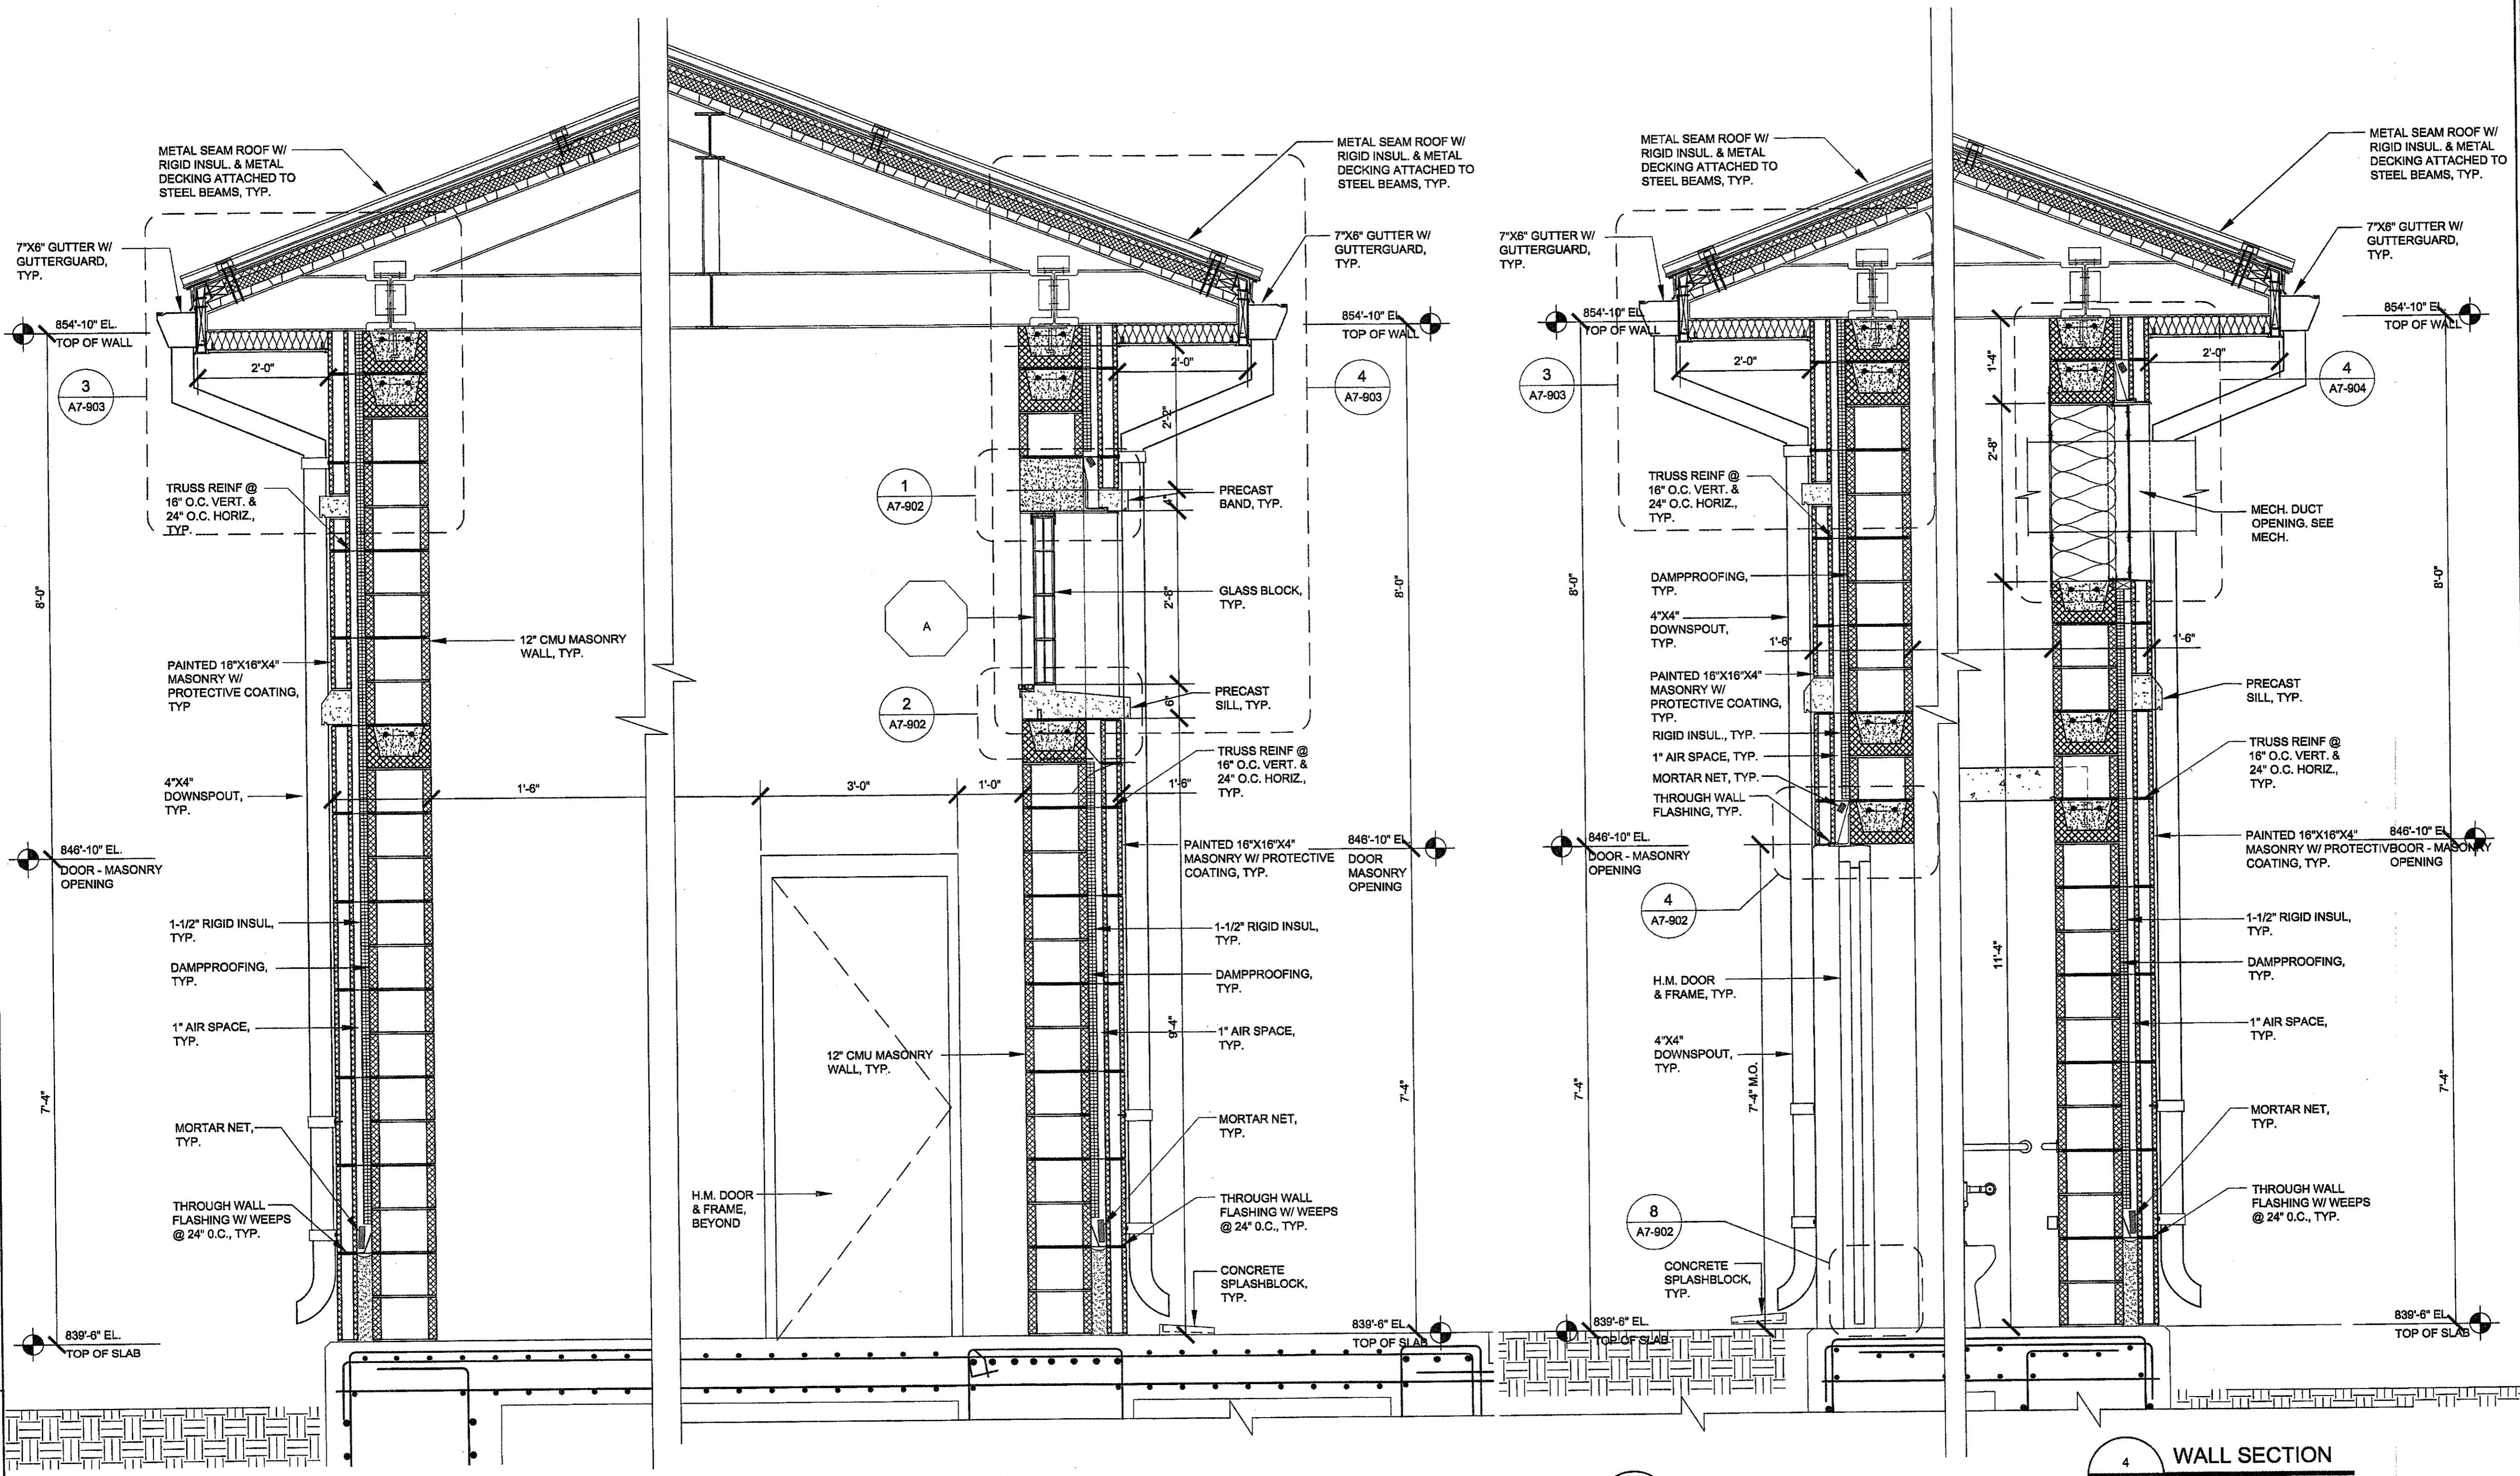


1 WALL SECTION
A7-701 SCALE: 3/4"=1'-0"

2 WALL SECTION
A7-701 SCALE: 3/4"=1'-0"

3 WALL SECTION
A7-701 SCALE: 3/4"=1'-0"

4 WALL SECTION
A7-701 SCALE: 3/4"=1'-0"

J. W. ROBINSON & ASSOCIATES
ARCHITECTS • INTERIOR DESIGNERS • URBAN PLANNERS
1020 RALPH DAVID ABERNATHY BLVD., S.W., ATLANTA, GEORGIA 30310
PHONE: (404) 753-4129 FAX: (404) 753-4485

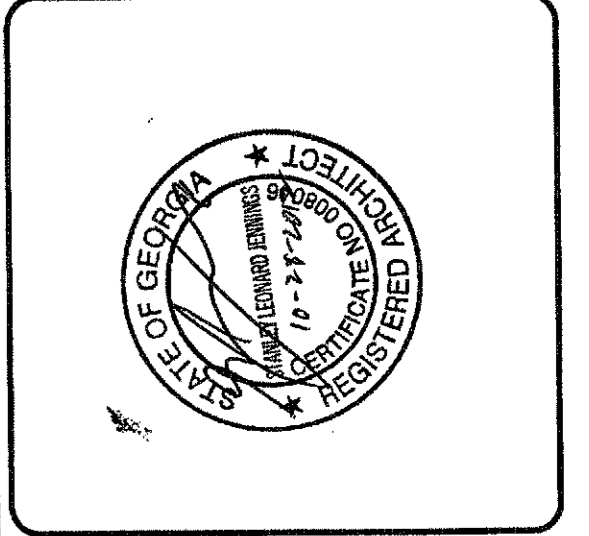

PEACHTREE CREEK SOUTH FORK
RELIEF STORAGE AND PUMPING STATION

CITY OF ATLANTA
DEPARTMENT OF WATERSHED MANAGEMENT

REV	DATE	REVISION DESCRIPTION

THIS LINE IS ONE INCH LONG WHEN PLOTTED FULL SCALE
THIS DRAWING MUST BE USED IN CONJUNCTION WITH THE APPLICABLE OR GOVERNING TECHNICAL SPECIFICATIONS AND OTHER CONTRACT DOCUMENTS.
PROJECT NO: FC-6260
DATE: OCTOBER 2012
RESP PROF: S.J. DESIGNER: LC CHECKER: LC

SHEET TITLE
ARCHITECTURAL
07 - JET MIX PUMP STATION
WALL SECTIONS

SHEET NO. A7-701 REV. 0