




1 JET MIX STATION UPPER LEVEL PLUMBING PLAN
 P7-101 SCALE: 1/8"=1'-0" FIN. FLR. EL. 839'-6"

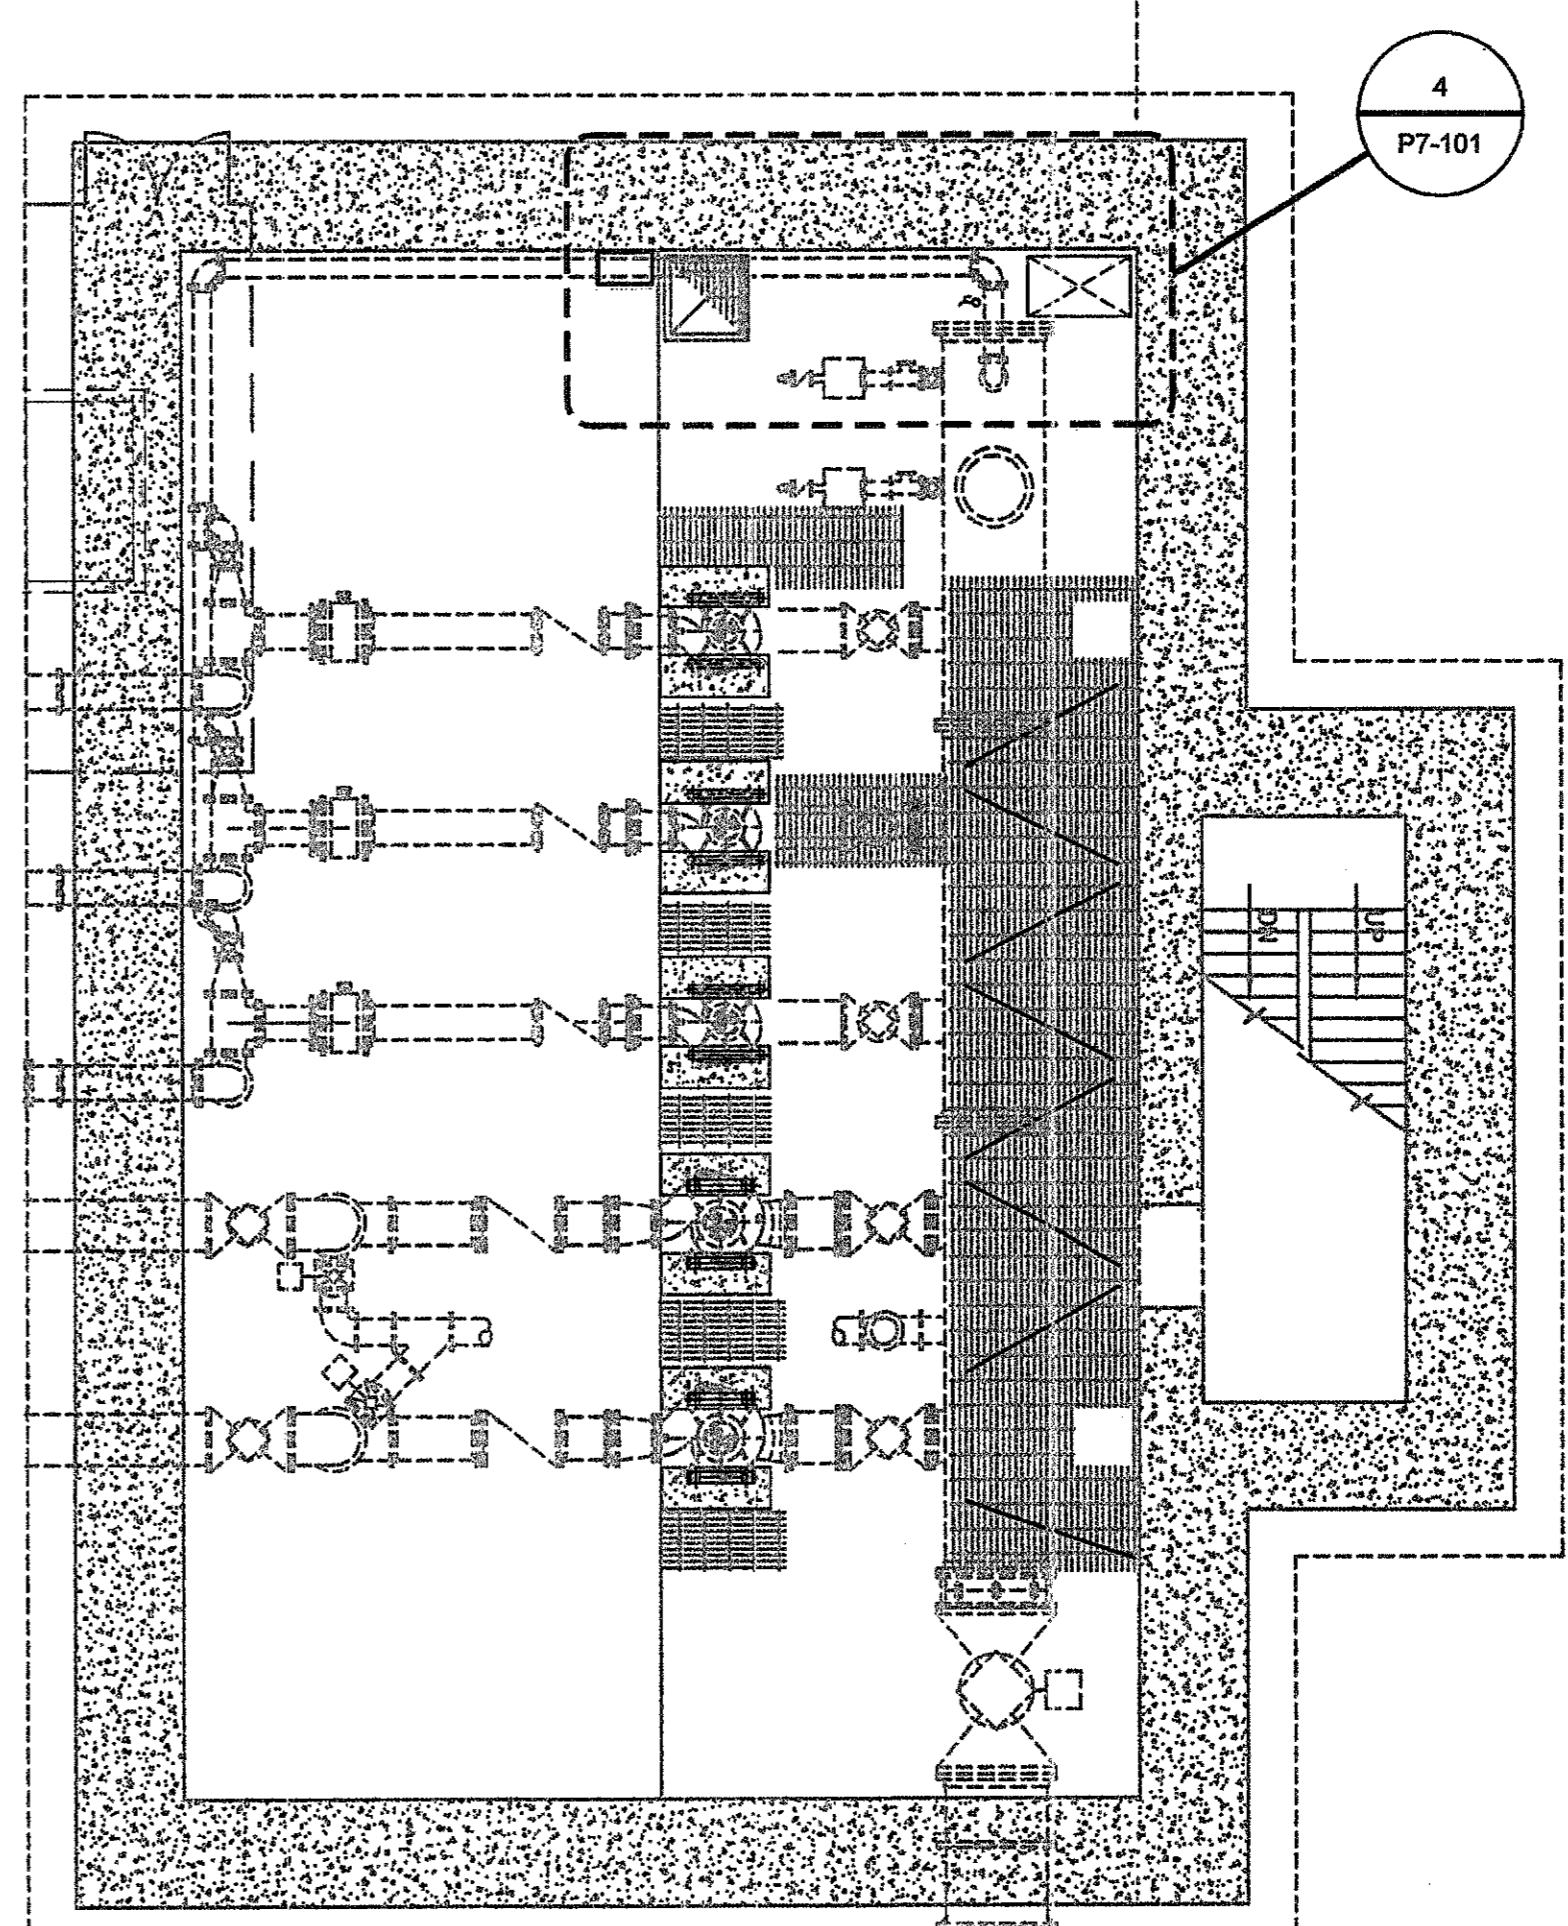


3 JET MIX STATION PLUMBING- LOWER LEVEL
 P7-101 SCALE: 3/8"=1'-0" FIN. FLR. EL. 795'-9"

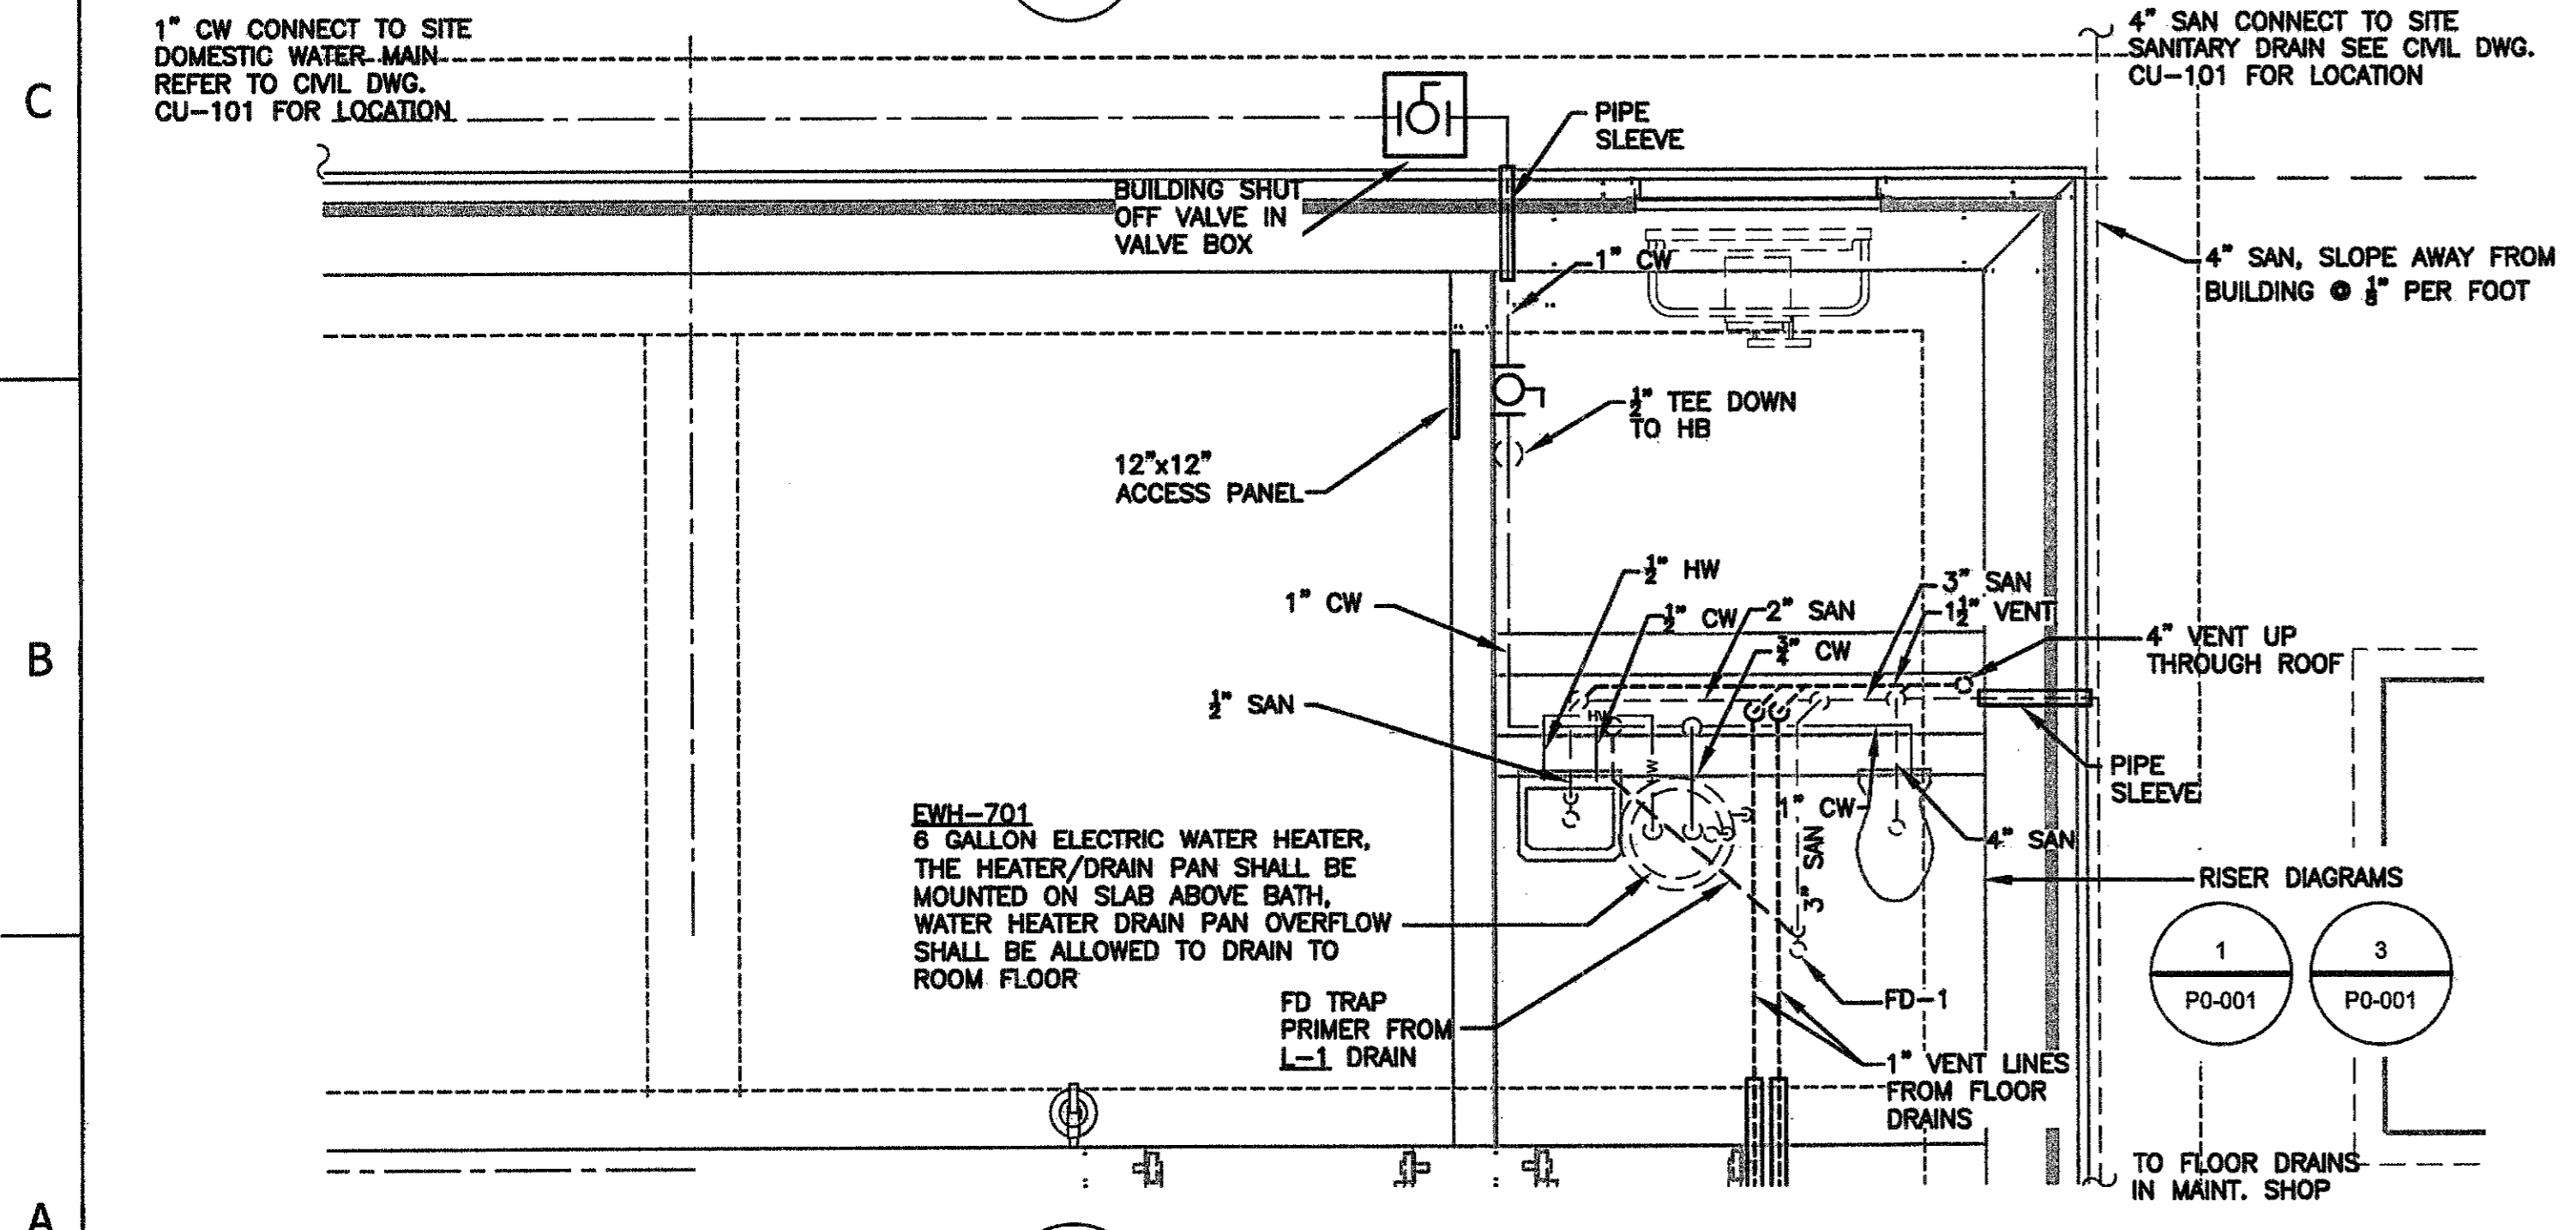


2 JET MIX STATION PLUMBING- ENLARGED BATH PLAN
 P7-101 SCALE: 3/8"=1'-0" FIN. FLR. EL. 839'-6"

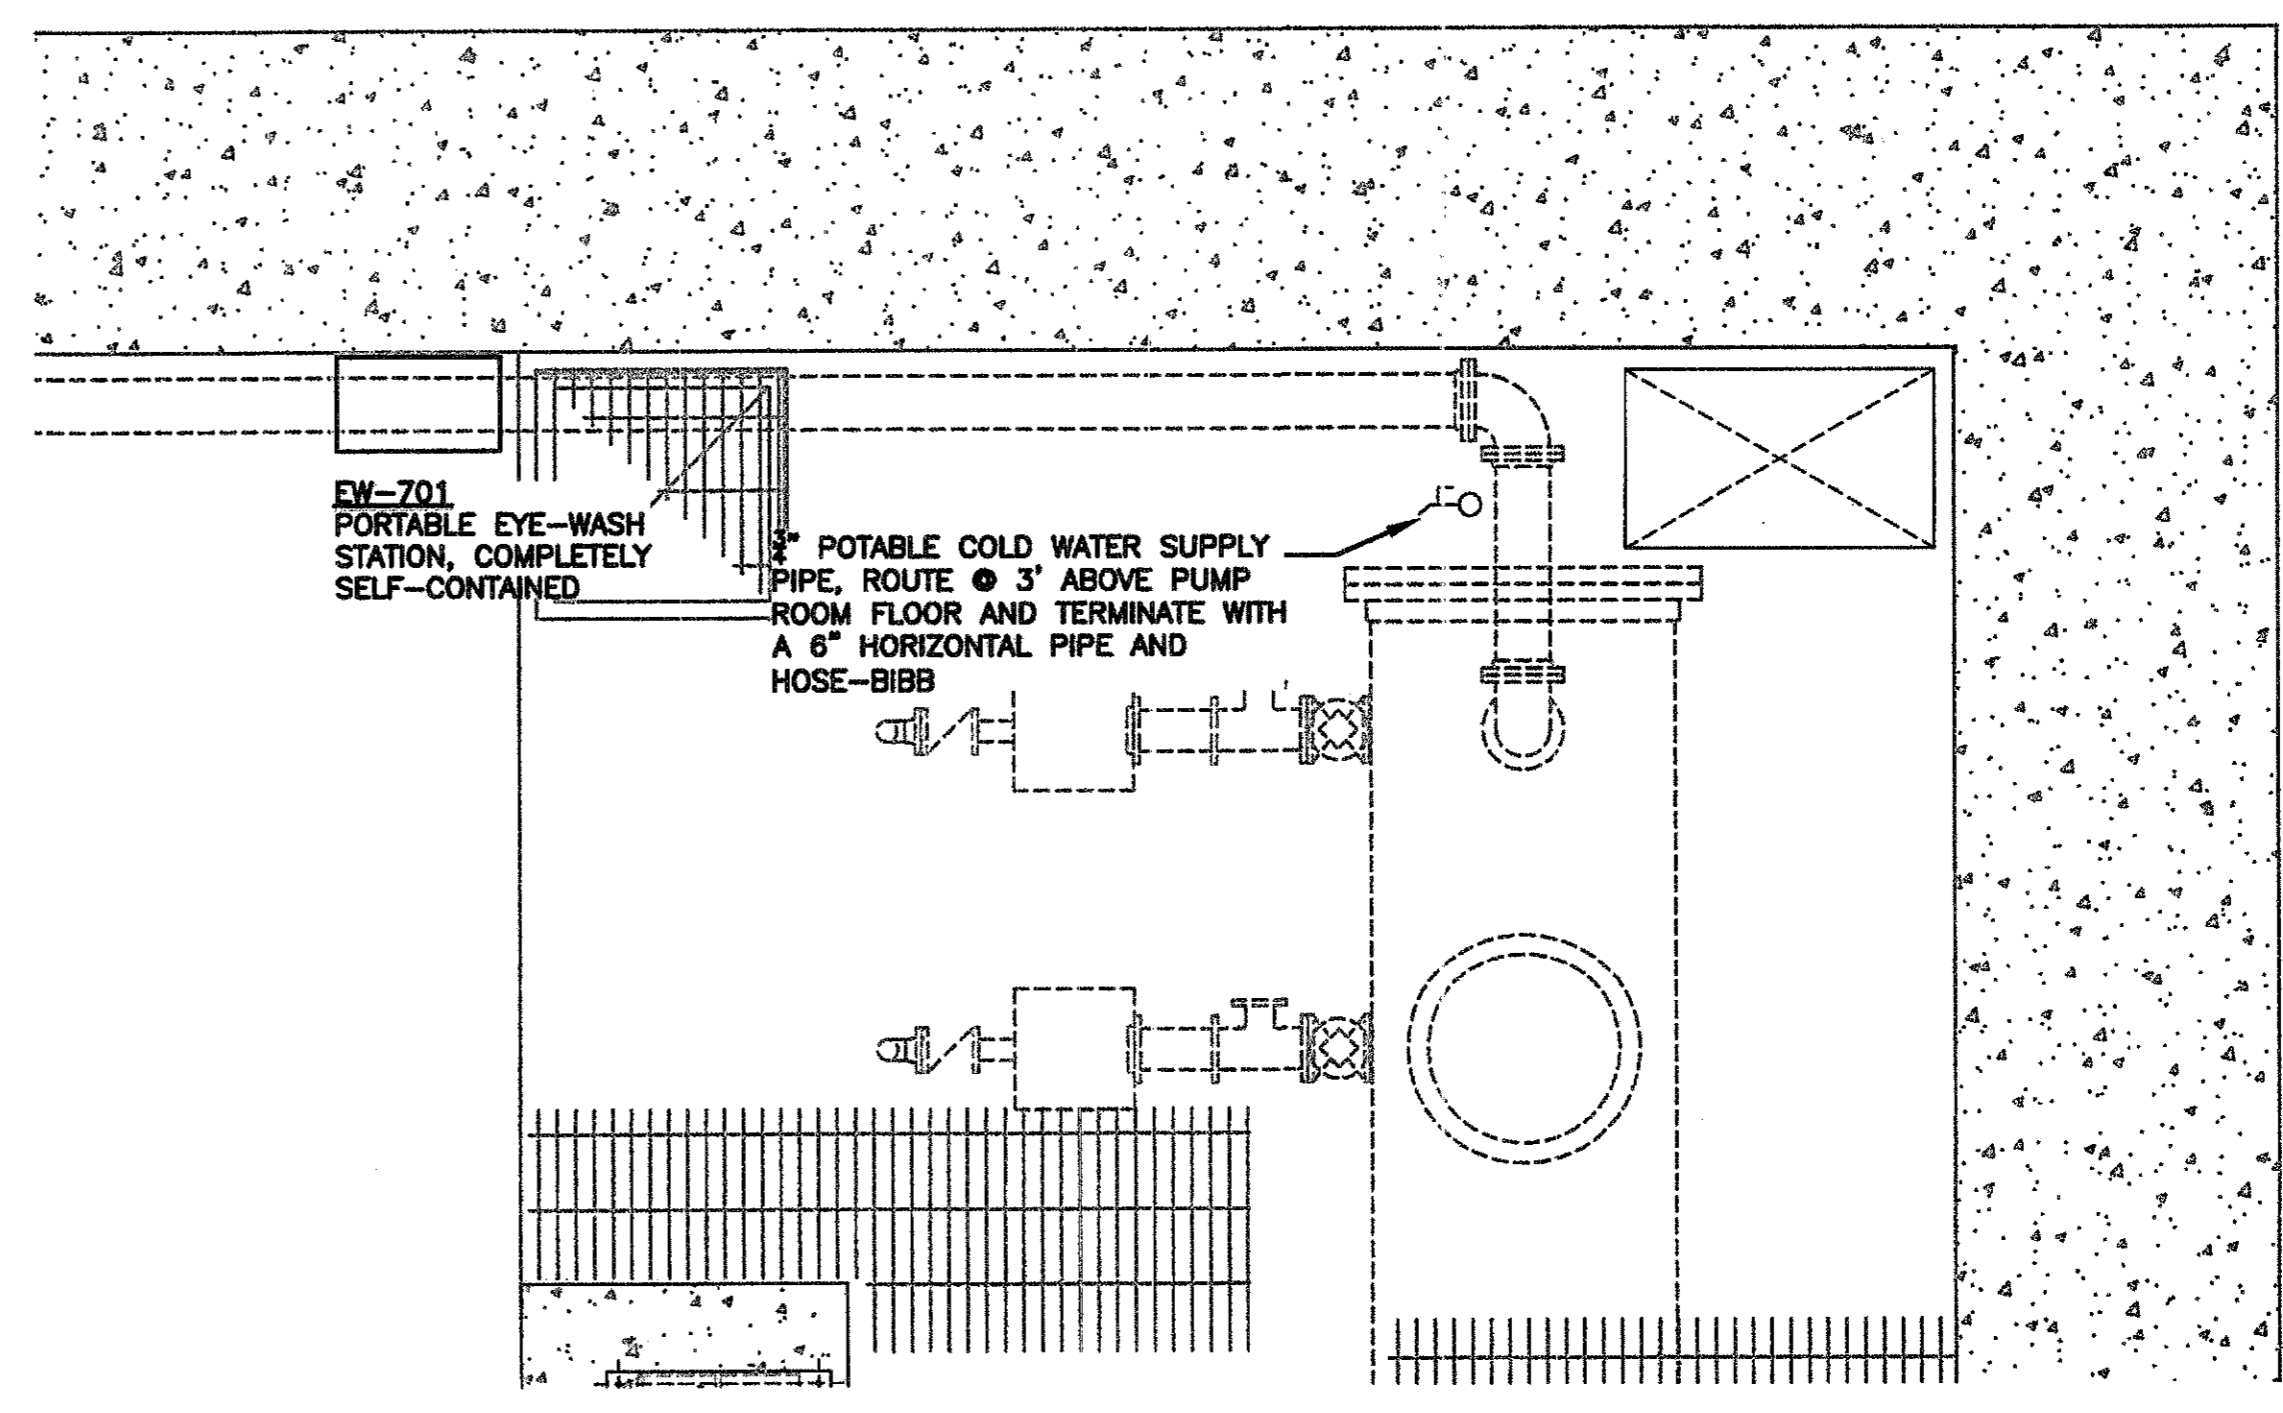

4 JET MIX STATION PLUMBING- ENLARGED LOWER LEVEL EYE-WASH
 P7-101 SCALE: 3/8"=1'-0" FIN. FLR. EL. 795'-9"

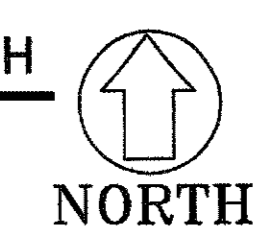

Atlanta

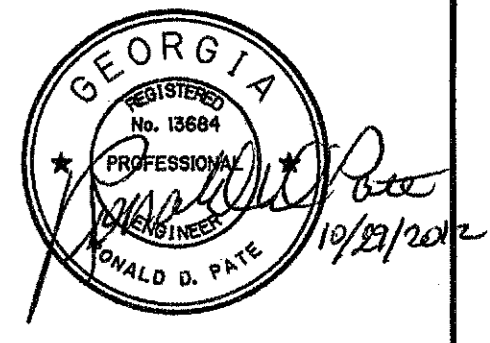

PEACHTREE CREEK SOUTH FORK
 RELIEF STORAGE AND PUMPING STATION
 DEPARTMENT of WATERSHED MANAGEMENT
 CITY OF ATLANTA

REV	DATE	REVISION DESCRIPTION
0	10/29/12	100 PERCENT BID PACKAGE

THIS LINE IS ONE INCH LONG WHEN PLOTTED FULL SCALE
 THIS DRAWING MUST BE USED IN CONJUNCTION WITH THE APPLICABLE OR GOVERNING TECHNICAL SPECIFICATIONS AND OTHER CONTRACT DOCUMENTS.
 PROJECT NO: FC-6260
 DATE: OCTOBER 2012
 RESP PROF: RP DESIGNER: DC CHECKER: TB
 SHEET TITLE
 PLUMBING
 07 - JET MIXING PUMP STATION
 PLANS
 SHEET NO. P7-101 REV. 0