



ALL PIPES SHALL INSTALLED USING TYPE 4 BEDDING
(SEE DETAIL ON SHEET C-10)

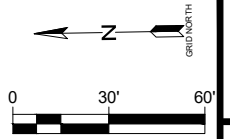

ESI
ENGINEERING STRATEGIES, INC.
3855 SHALLOUFORD ROAD, SUITE 525
MARIETTA, GA 30062
(770) 425-0001

- NOTES:**
1. ALL MANHOLES SHALL BE GDOT TYPE 1011-A OR EQUAL
 2. ALL DROP INLETS SHALL BE GDOT TYPE 1019-A OR EQUAL
 3. ALL FLARED END SECTIONS SHALL BE GDOT TYPE 1120 OR EQUAL
 4. ALL HEADWALLS SHALL BE GDOT TYPE 1001-B OR EQUAL

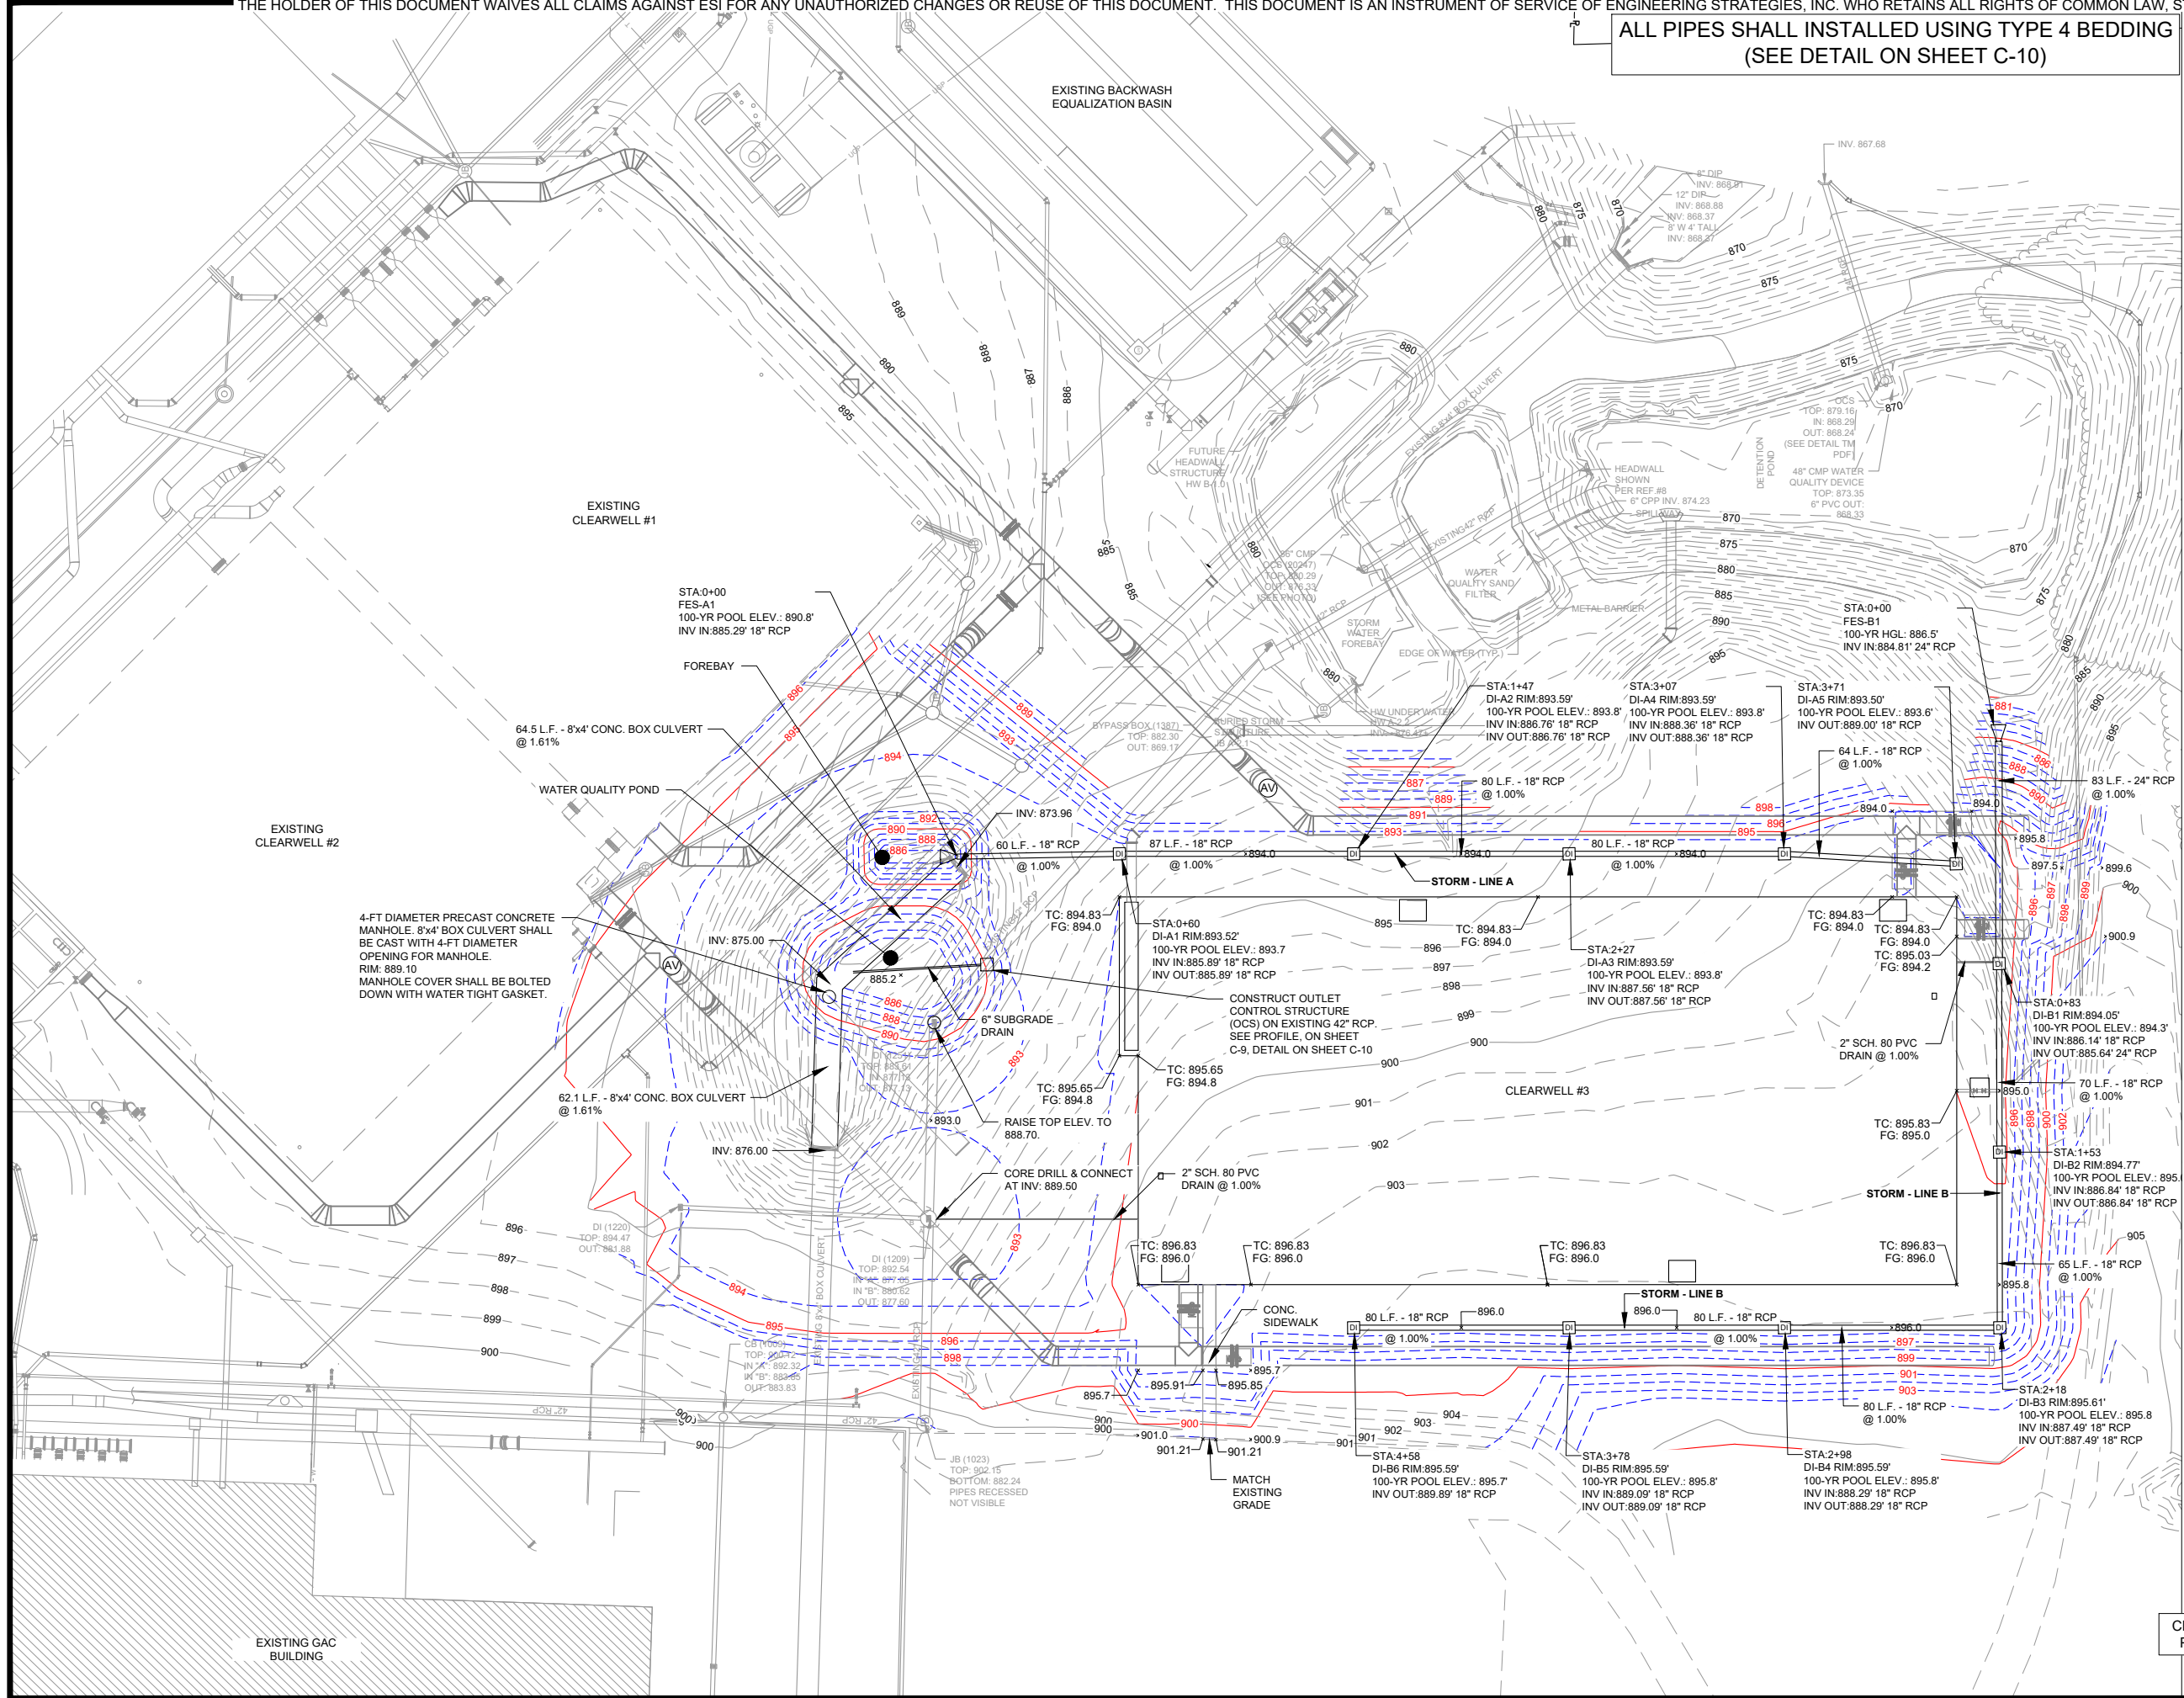

DATE	REVISION

DATE: MAY 2020
PROJECT NUMBER: 505-9005-33-19-0000

COBB COUNTY-MARIETTA WATER AUTHORITY
WYCKOFF WTP CLEARWELL #3
GRADING AND DRAINAGE PLAN

CERTIFIED EROSION CONTROL DESIGN
PROFESSIONAL NUMBER 0000019365

SHEET NO.
C-3